



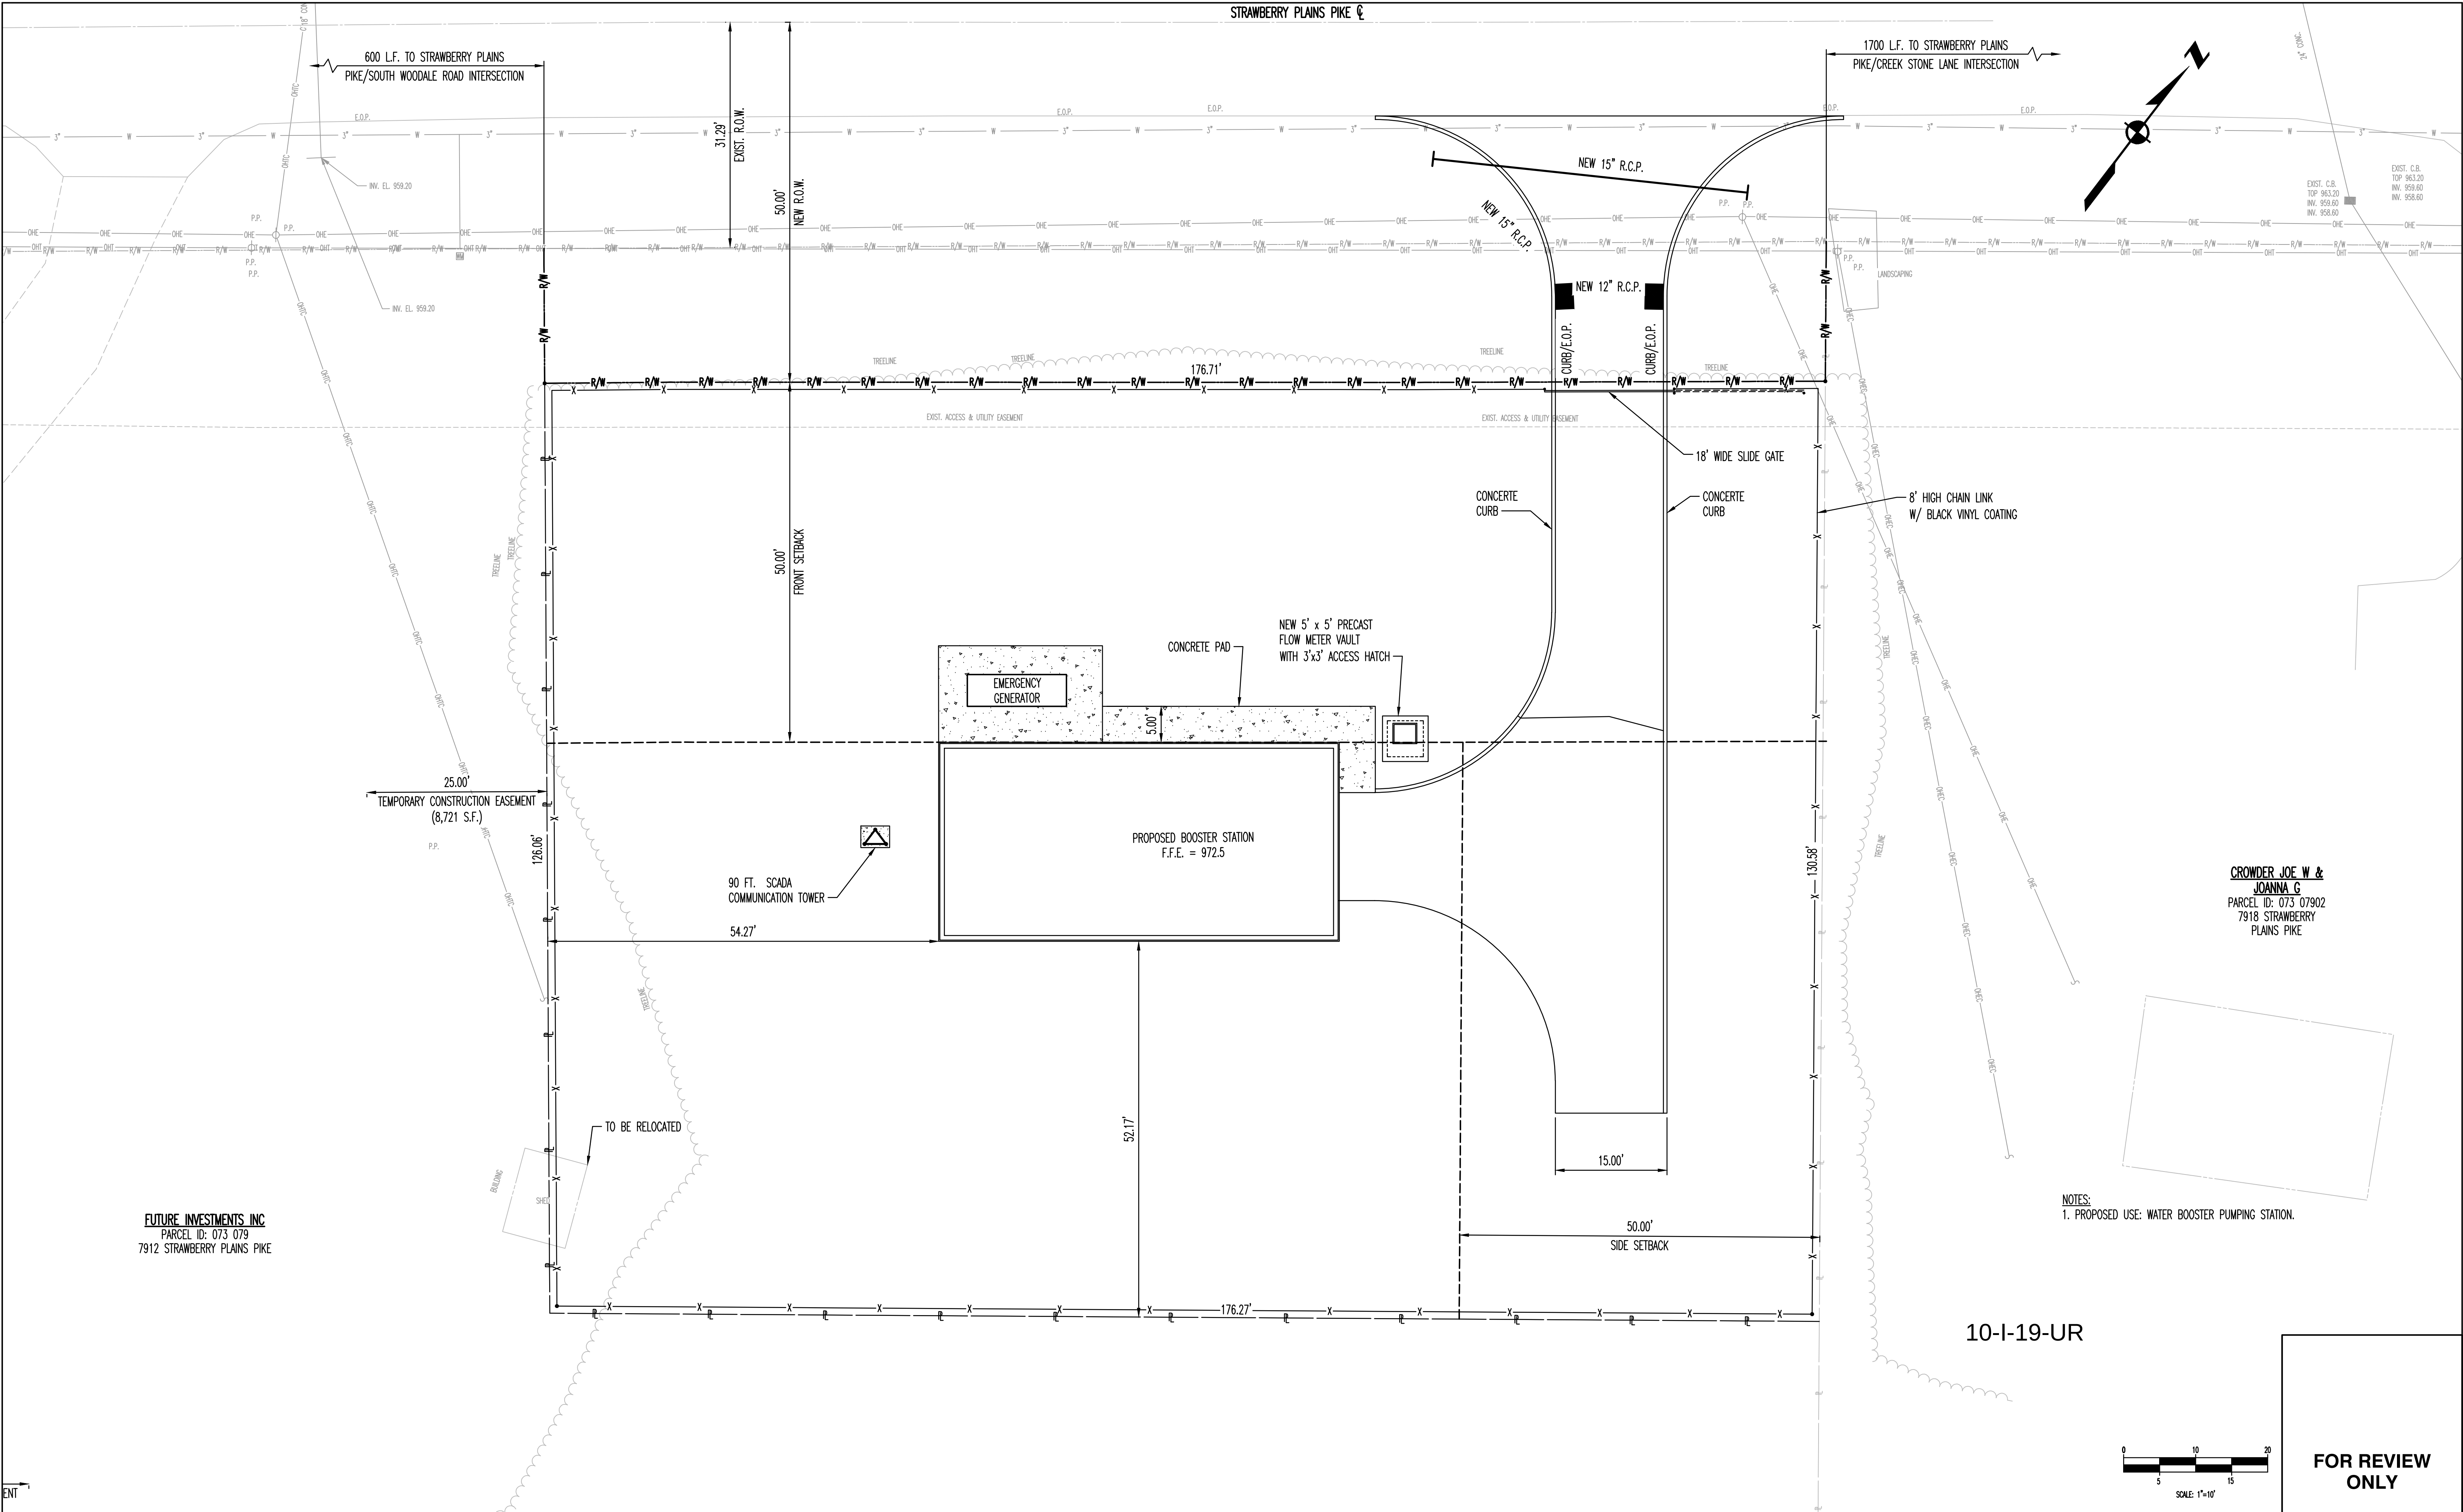

CROWDER JOE W &
JOANNA G
PARCEL ID: 073 07902
7918 STRAWBERRY
PLAINS PIKE

NOTES:
1. PROPOSED USE: WATER BOOSTER PUMPING STATION.


10-I-19-UR

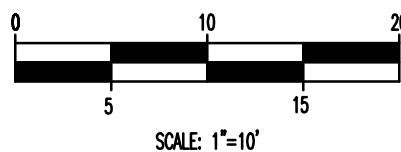

FOR REVIEW
ONLY

ENGINEER  LDA ENGINEERING	DESIGNED : GSB	APPROVED						SCALE	KUB KNOXVILLE UTILITIES BOARD STRAWBERRY PLAINS BOOSTER STATION KNOX COUNTY, TENNESSEE	WATER SYSTEM IMPROVEMENTS		
	DRAWN : BAS	ENGINEER						AS SHOWN				
		KNOXVILLE UTILITIES BOARD						DATE				
	CHECKED :							5-19				
			NO.	DATE	REVISION	APPR.					SHEET 2	OF
												SHEETS


P:\KUB25\GEOMATICS\DESIGN\PUMP STATION\DWG\SUBSYSTEM SITE PLAN.DWG, 8/26/2019 2:18 PM, JAMES C. GIBSON

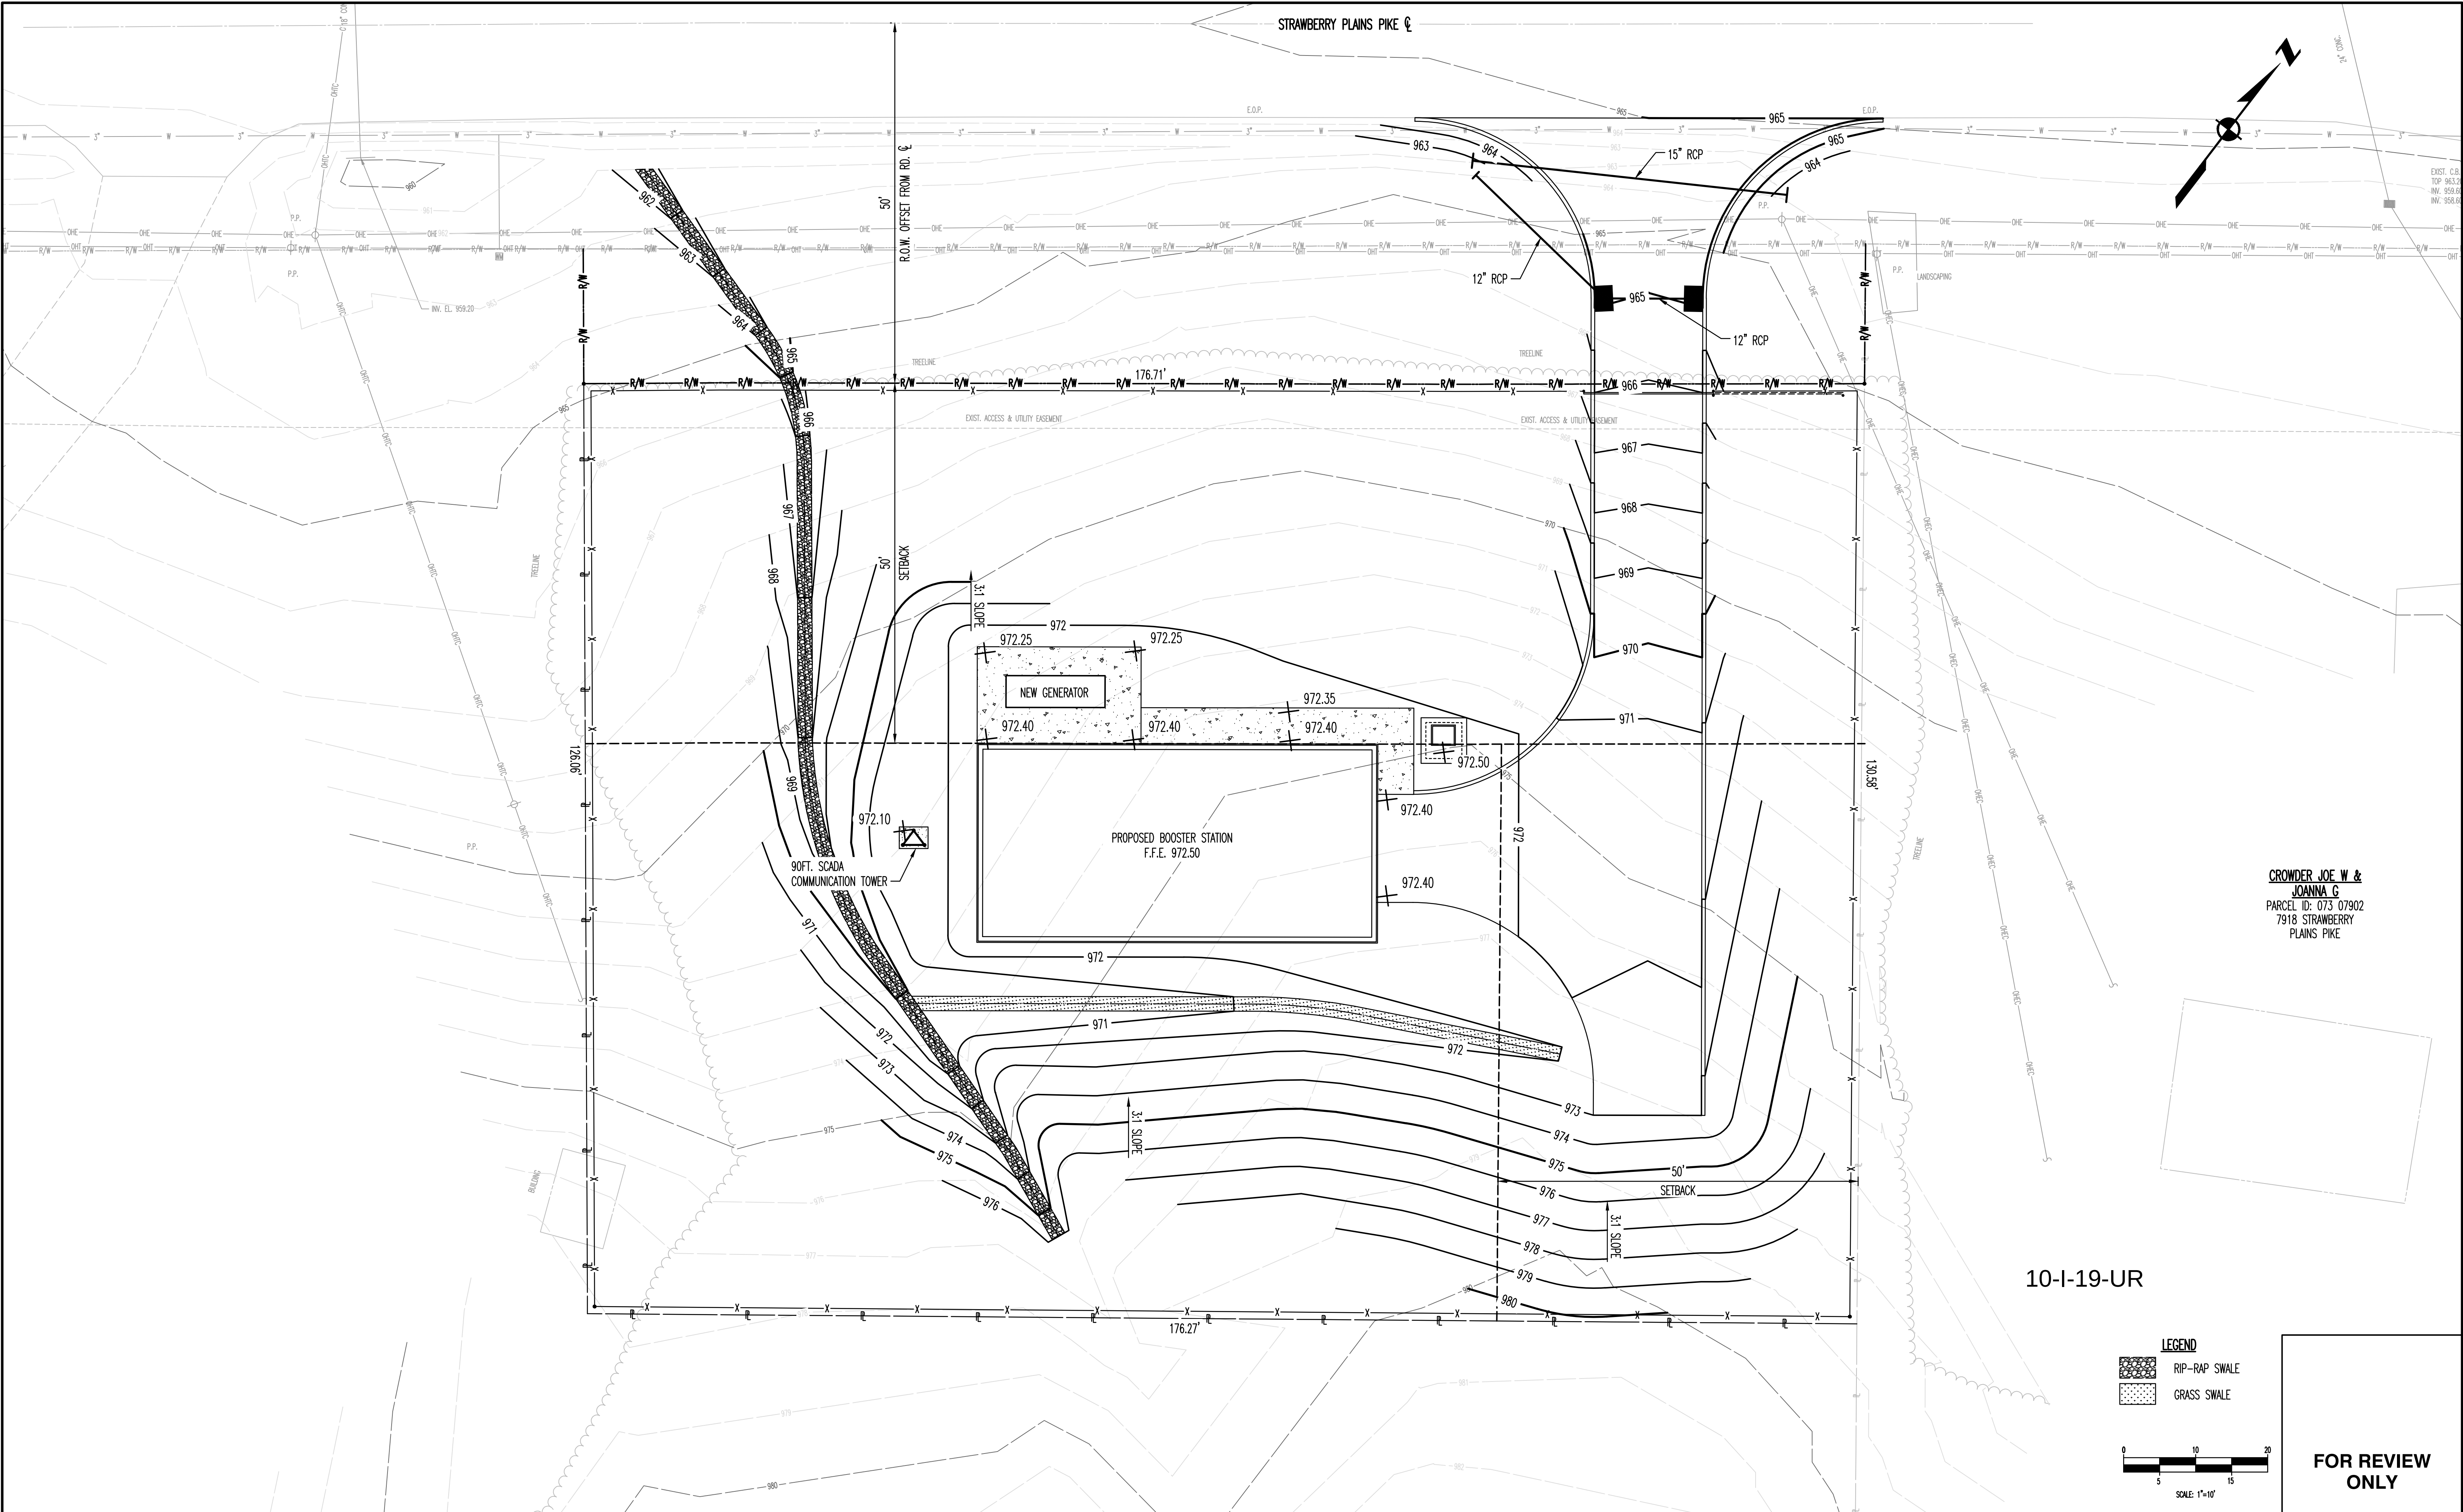

CROWDER JOE W &
JOANNA G
PARCEL ID: 073 07902
7918 STRAWBERRY
PLAINS PIKE

10-I-19-UR

- LEGEND
- RIP-RAP SWALE
 - GRASS SWALE

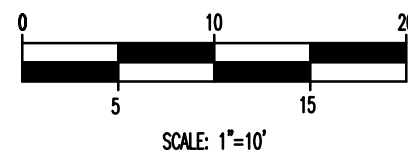

FOR REVIEW
ONLY

ENGINEER



LDA ENGINEERING

DESIGNED : GSB

DRAWN : BAS

CHECKED :

APPROVED

ENGINEER

KNOXVILLE UTILITIES BOARD

NO.	DATE	REVISION	APPR.

SCALE

1"=10'

DATE

8-19





KNOXVILLE UTILITIES BOARD
STRAWBERRY PLAINS BOOSTER STATION
KNOX COUNTY, TENNESSEE

WATER SYSTEM IMPROVEMENTS
GRADING AND DRAINAGE PLAN


SHEET 3

OF

SHEETS

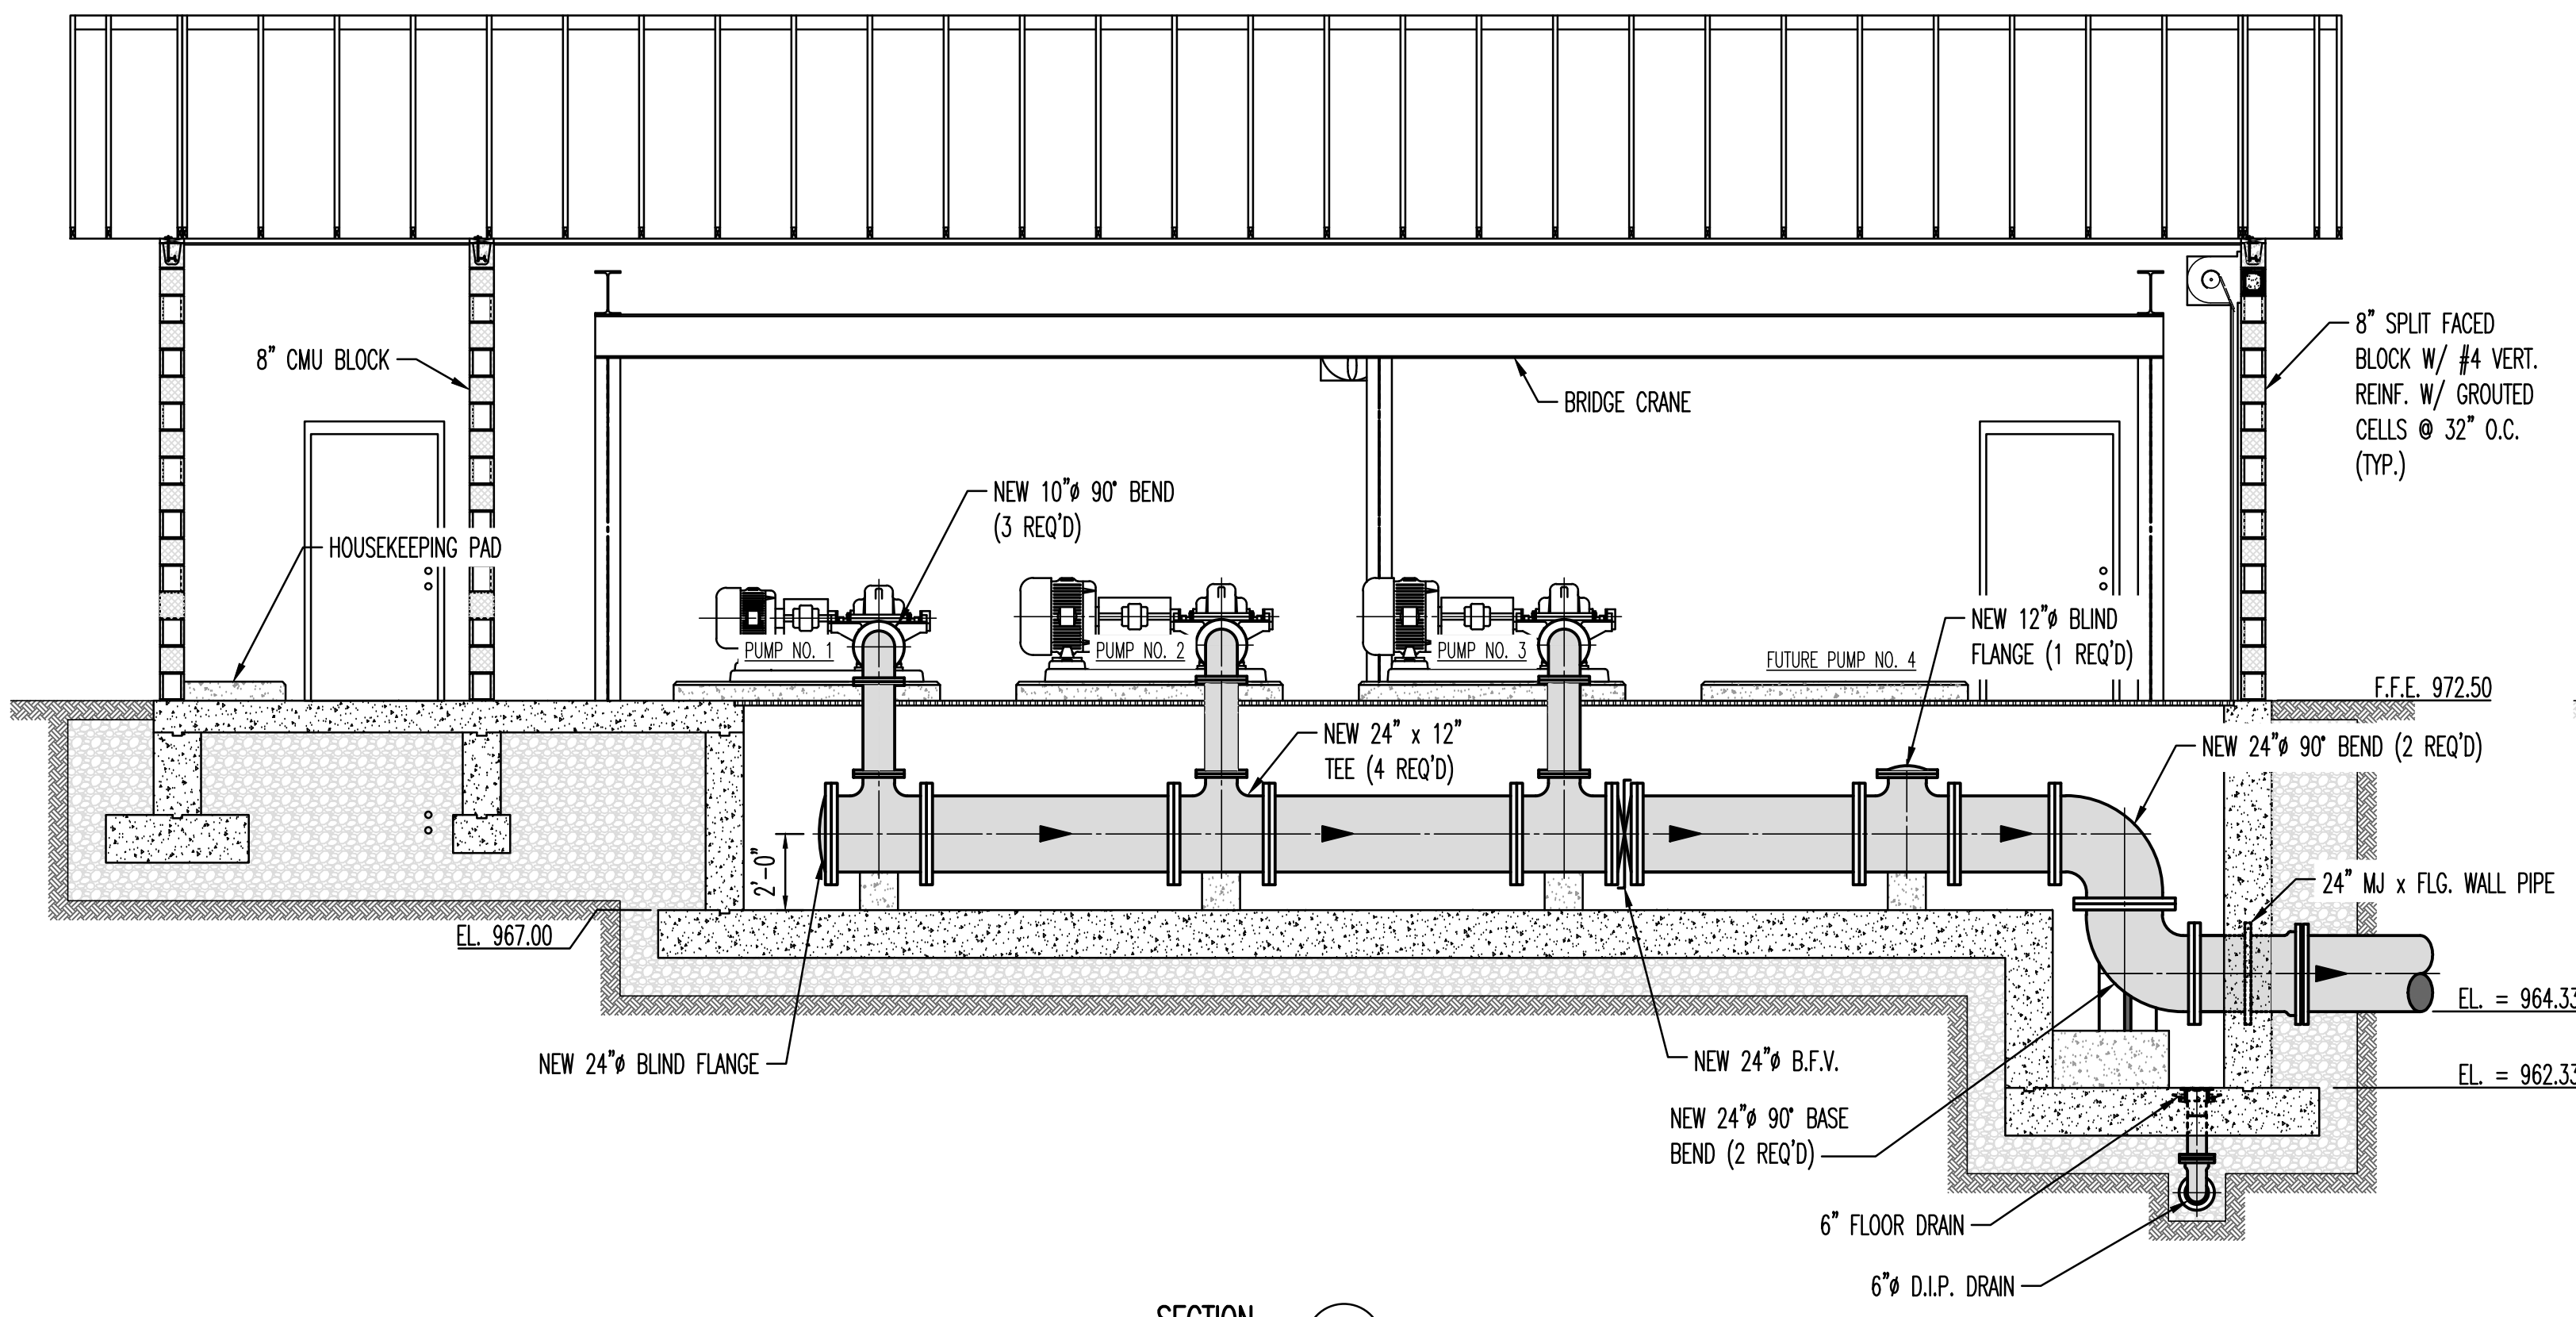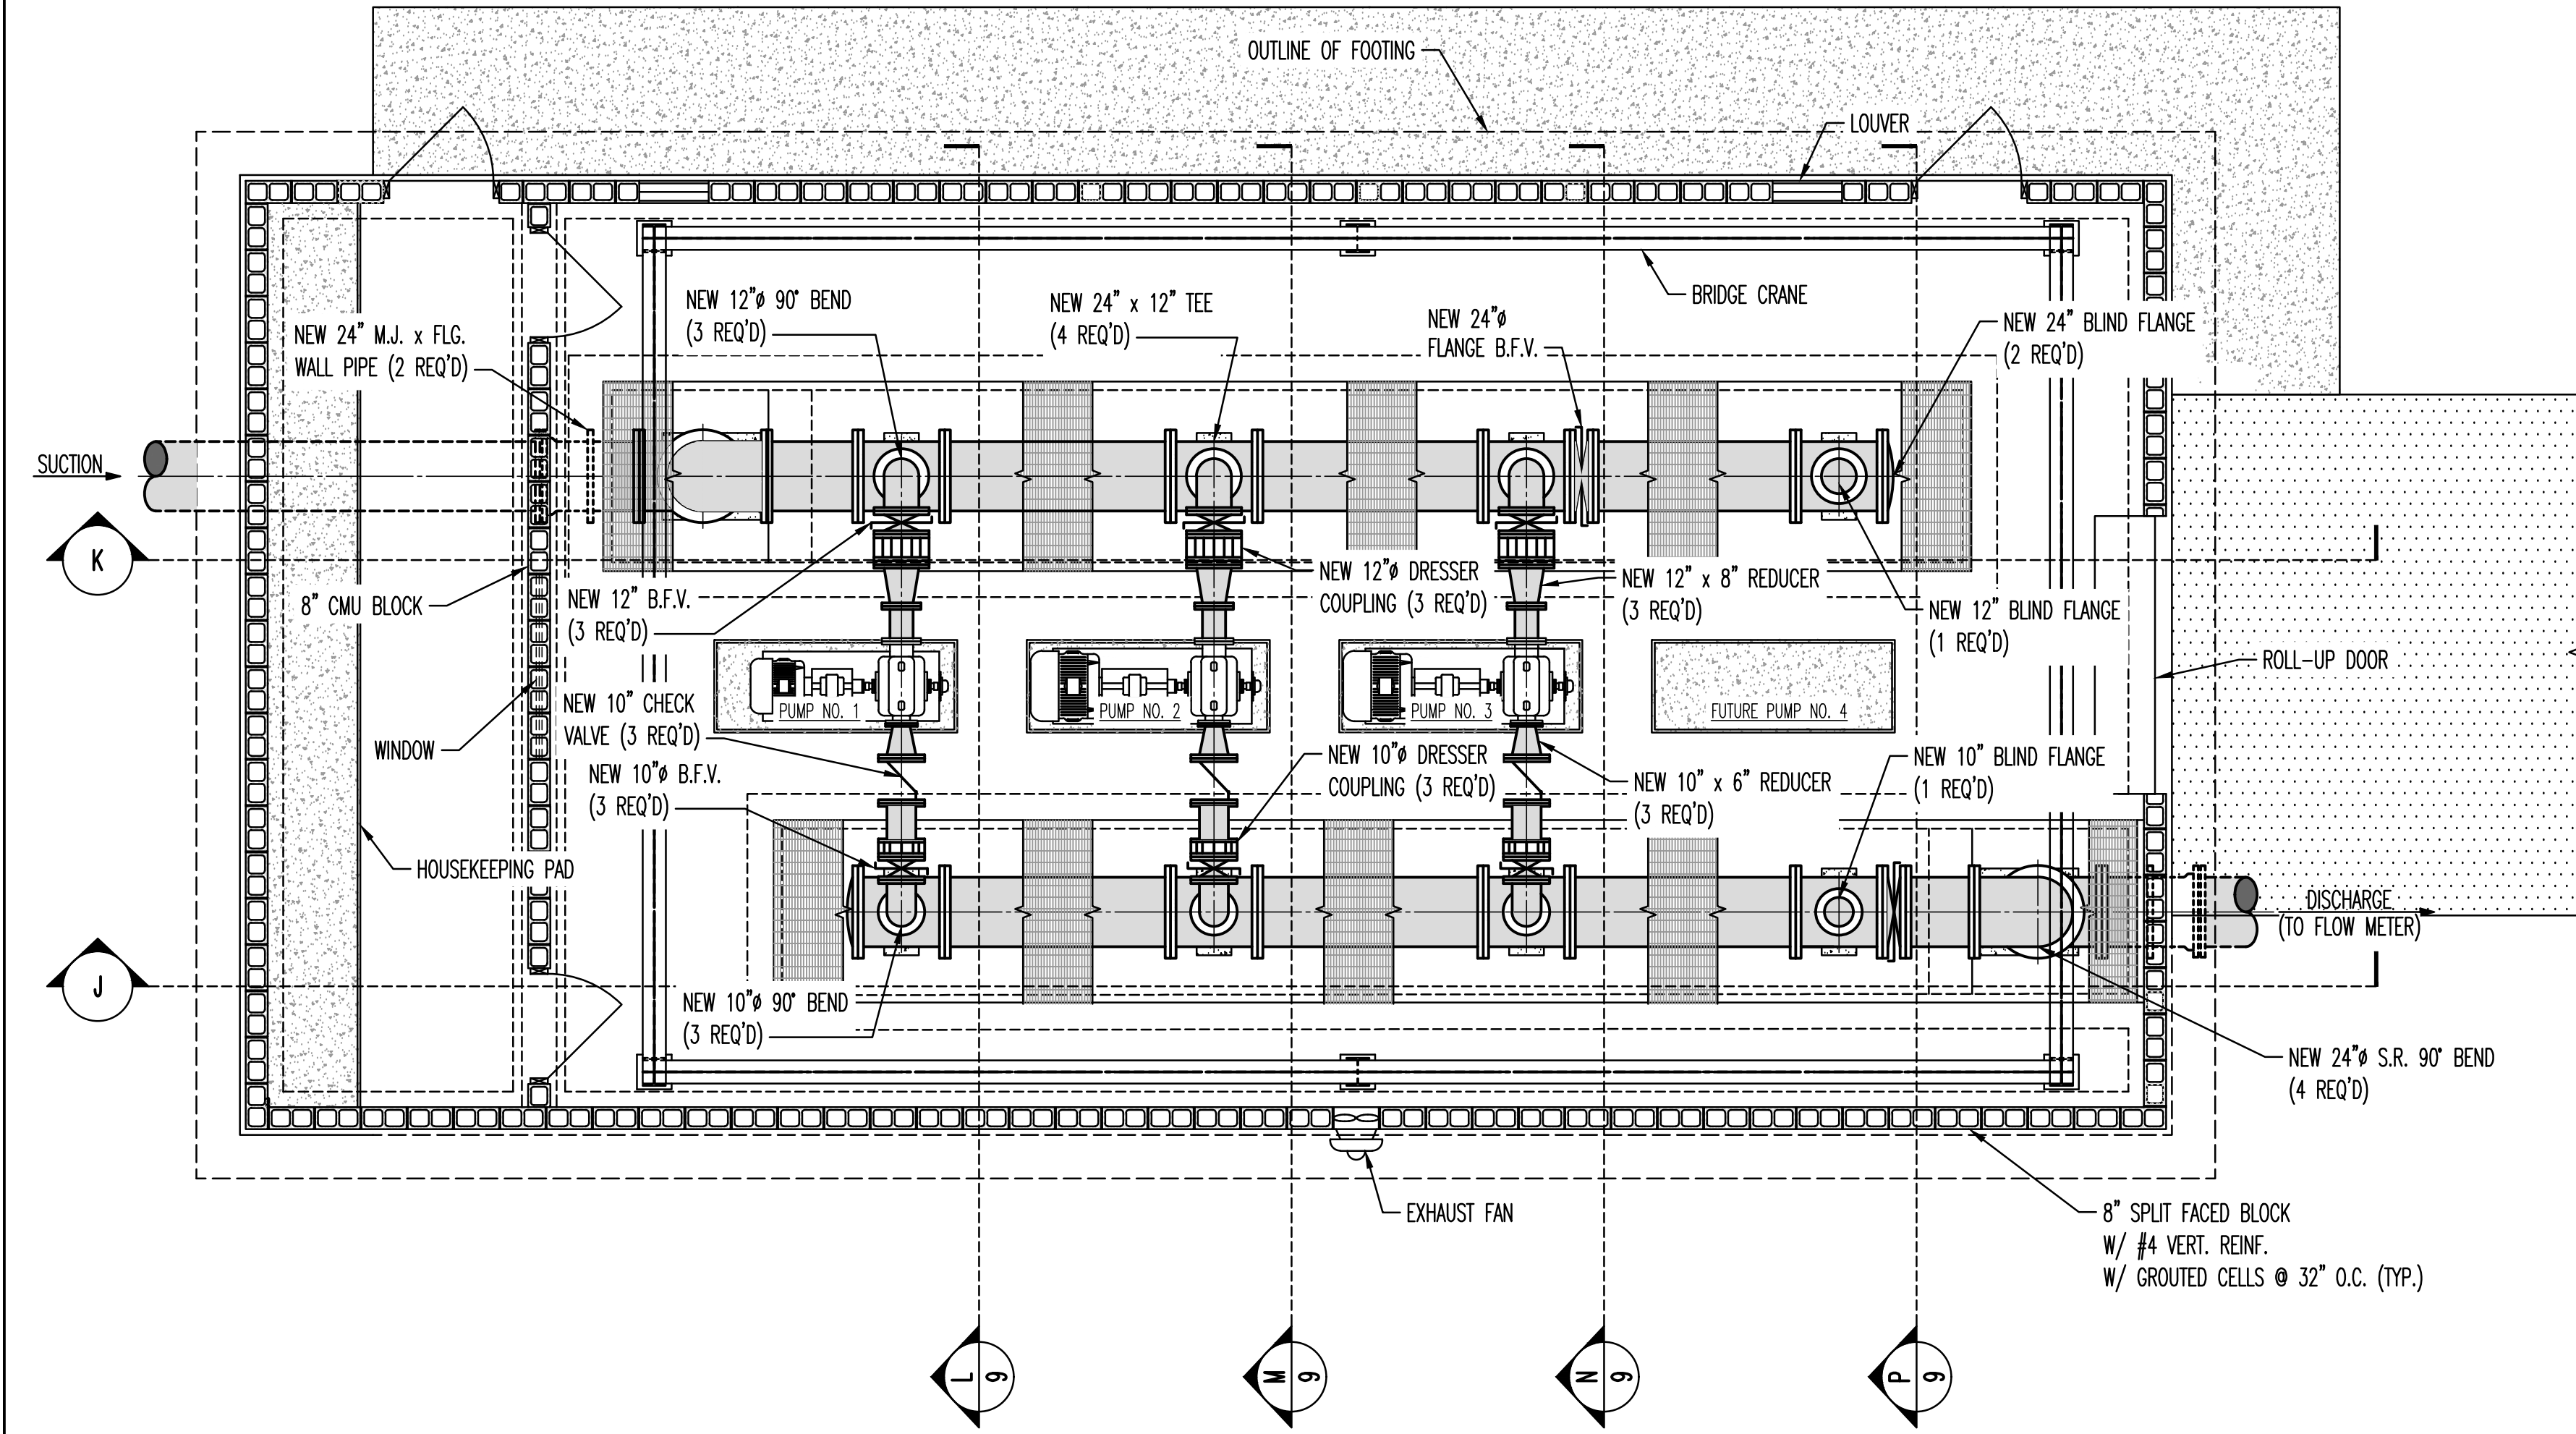

SECTION J
SCALE: 1/4" = 1'-0"

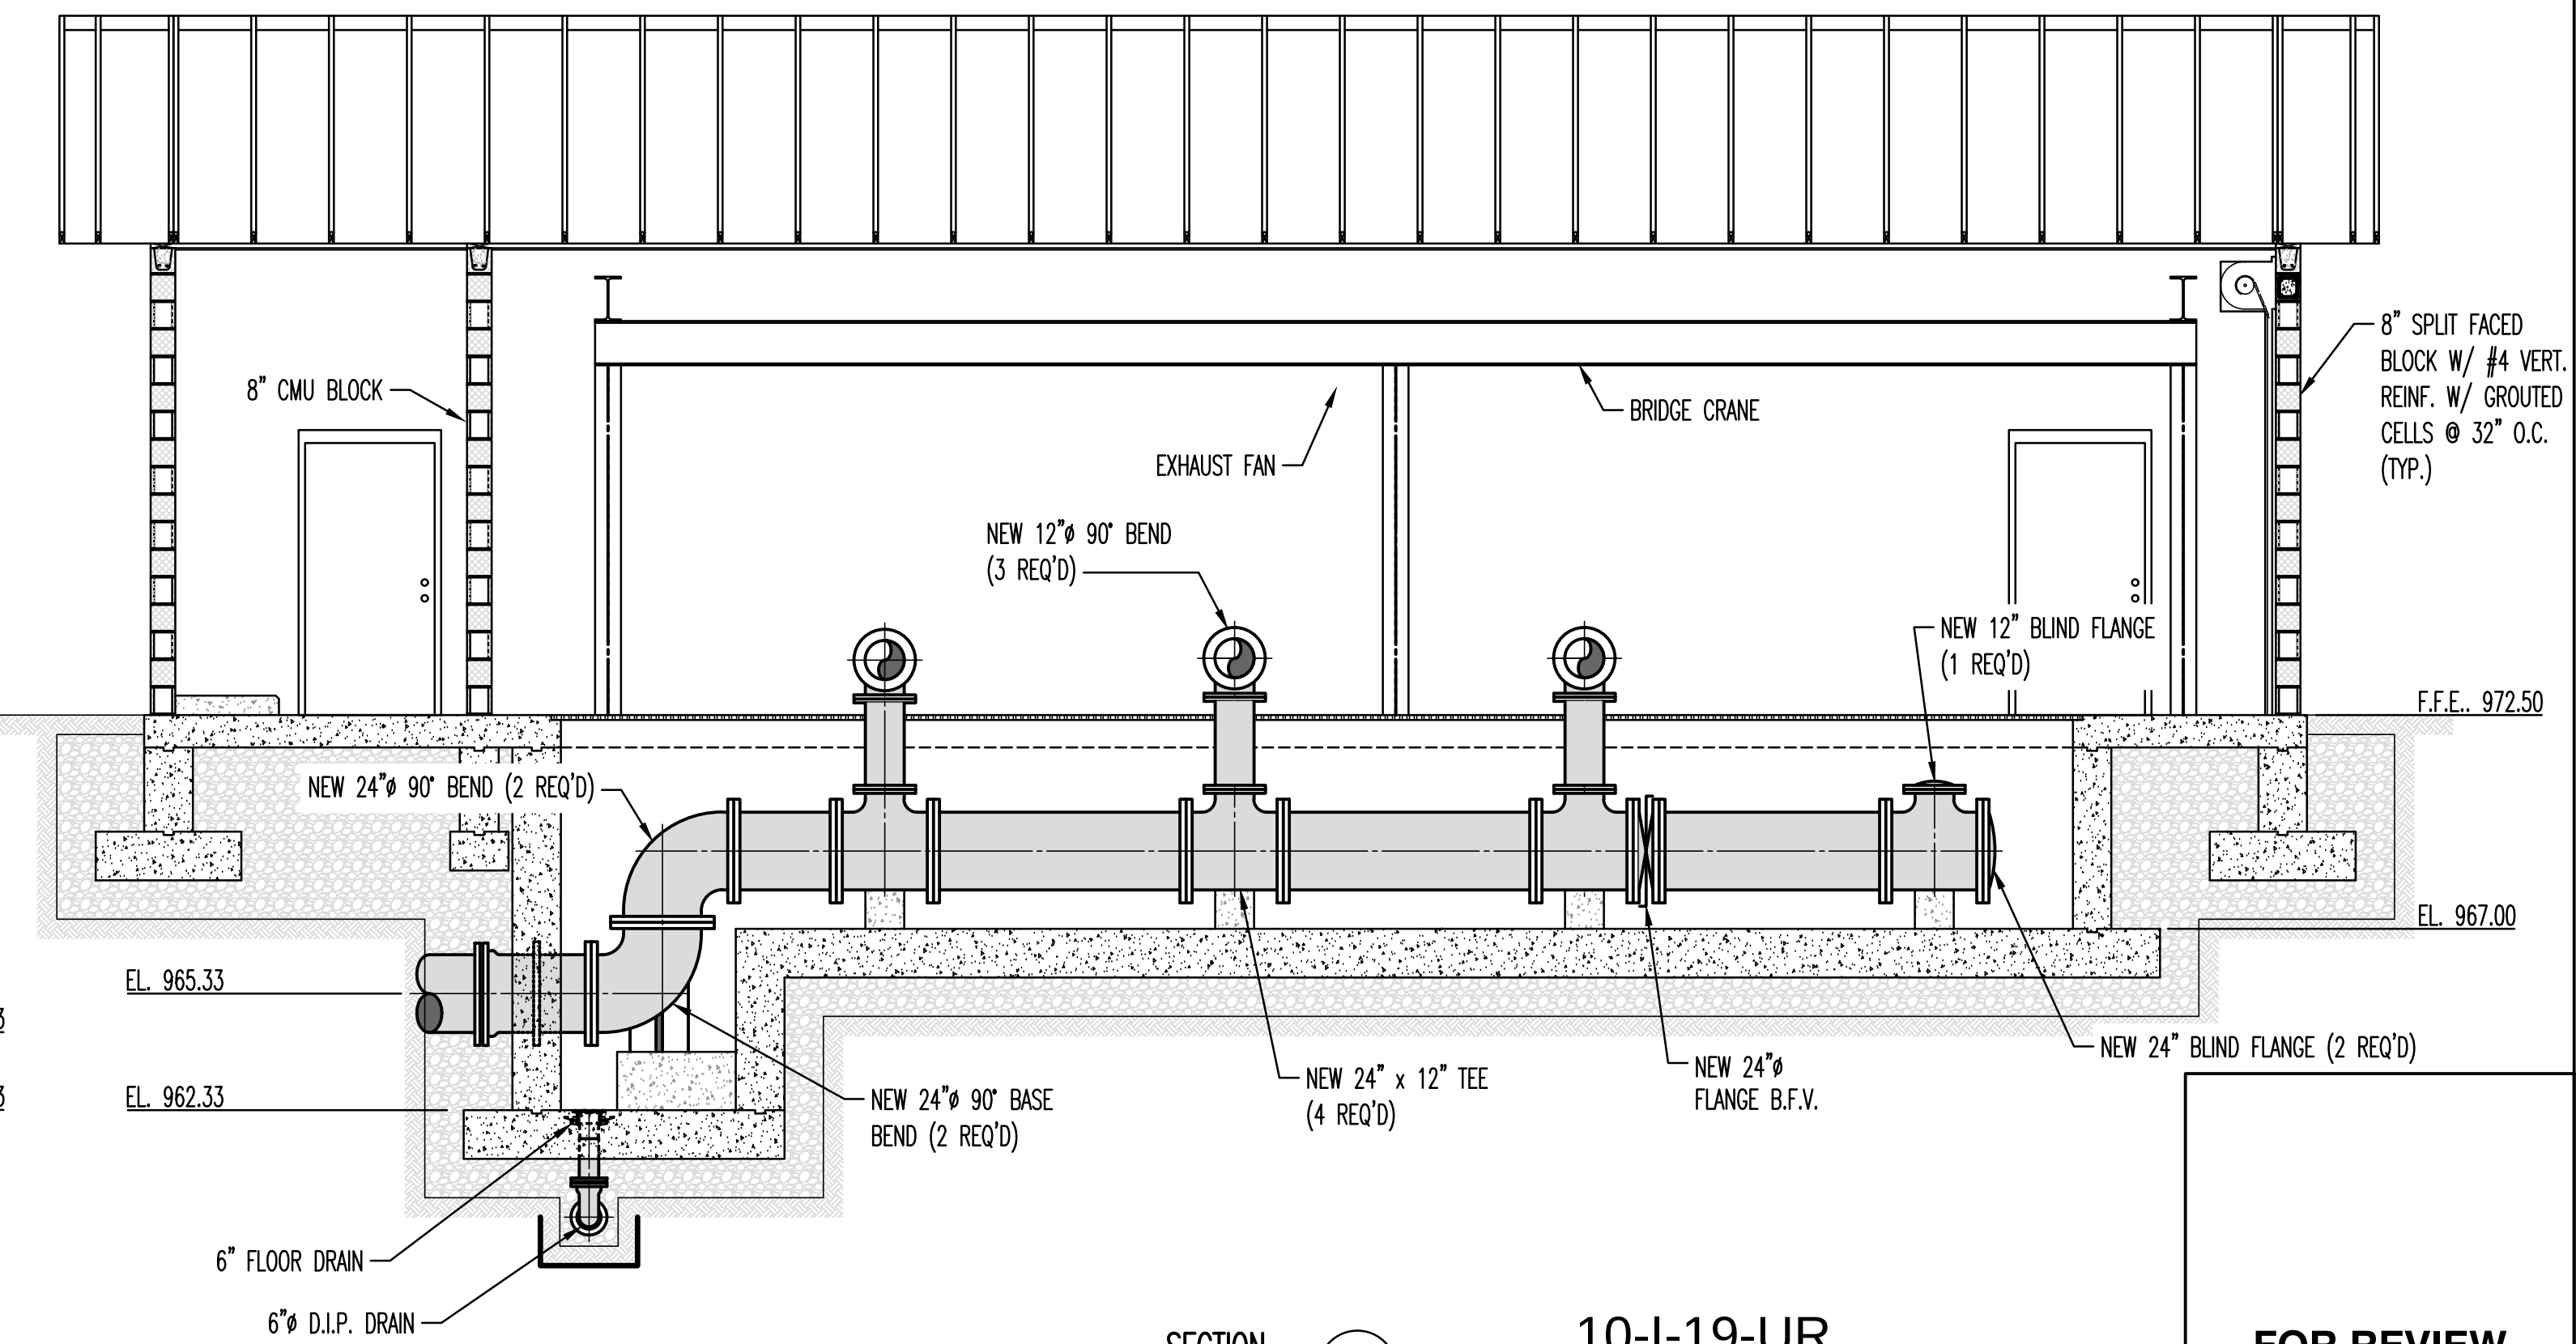


SECTION K
SCALE: 1/4" = 1'-0"

10-I-19-UR

FOR REVIEW ONLY

P:\KUB25\GEOMATICS\DESIGN\PUMP STATION\DWG\SUBSYSTEM_P5_MECHANICAL.DWG, 8/26/2019 2:21 PM, BRUCEY SMITH


ENGINEER  LDA ENGINEERING	DESIGNED : GSB	APPROVED					SCALE	 KNOXVILLE UTILITIES BOARD STRAWBERRY PLAINS BOOSTER STATION KNOX COUNTY, TENNESSEE	WATER SYSTEM IMPROVEMENTS MECHANICAL PLAN AND SECTIONS		
		ENGINEER					AS SHOWN				
	DRAWN : BAS						DATE				
	CHECKED :	KNOXVILLE UTILITIES BOARD					6-19				
			NO.	DATE	REVISION	APPR.				SHEET 8	
										OF	
											SHEETS

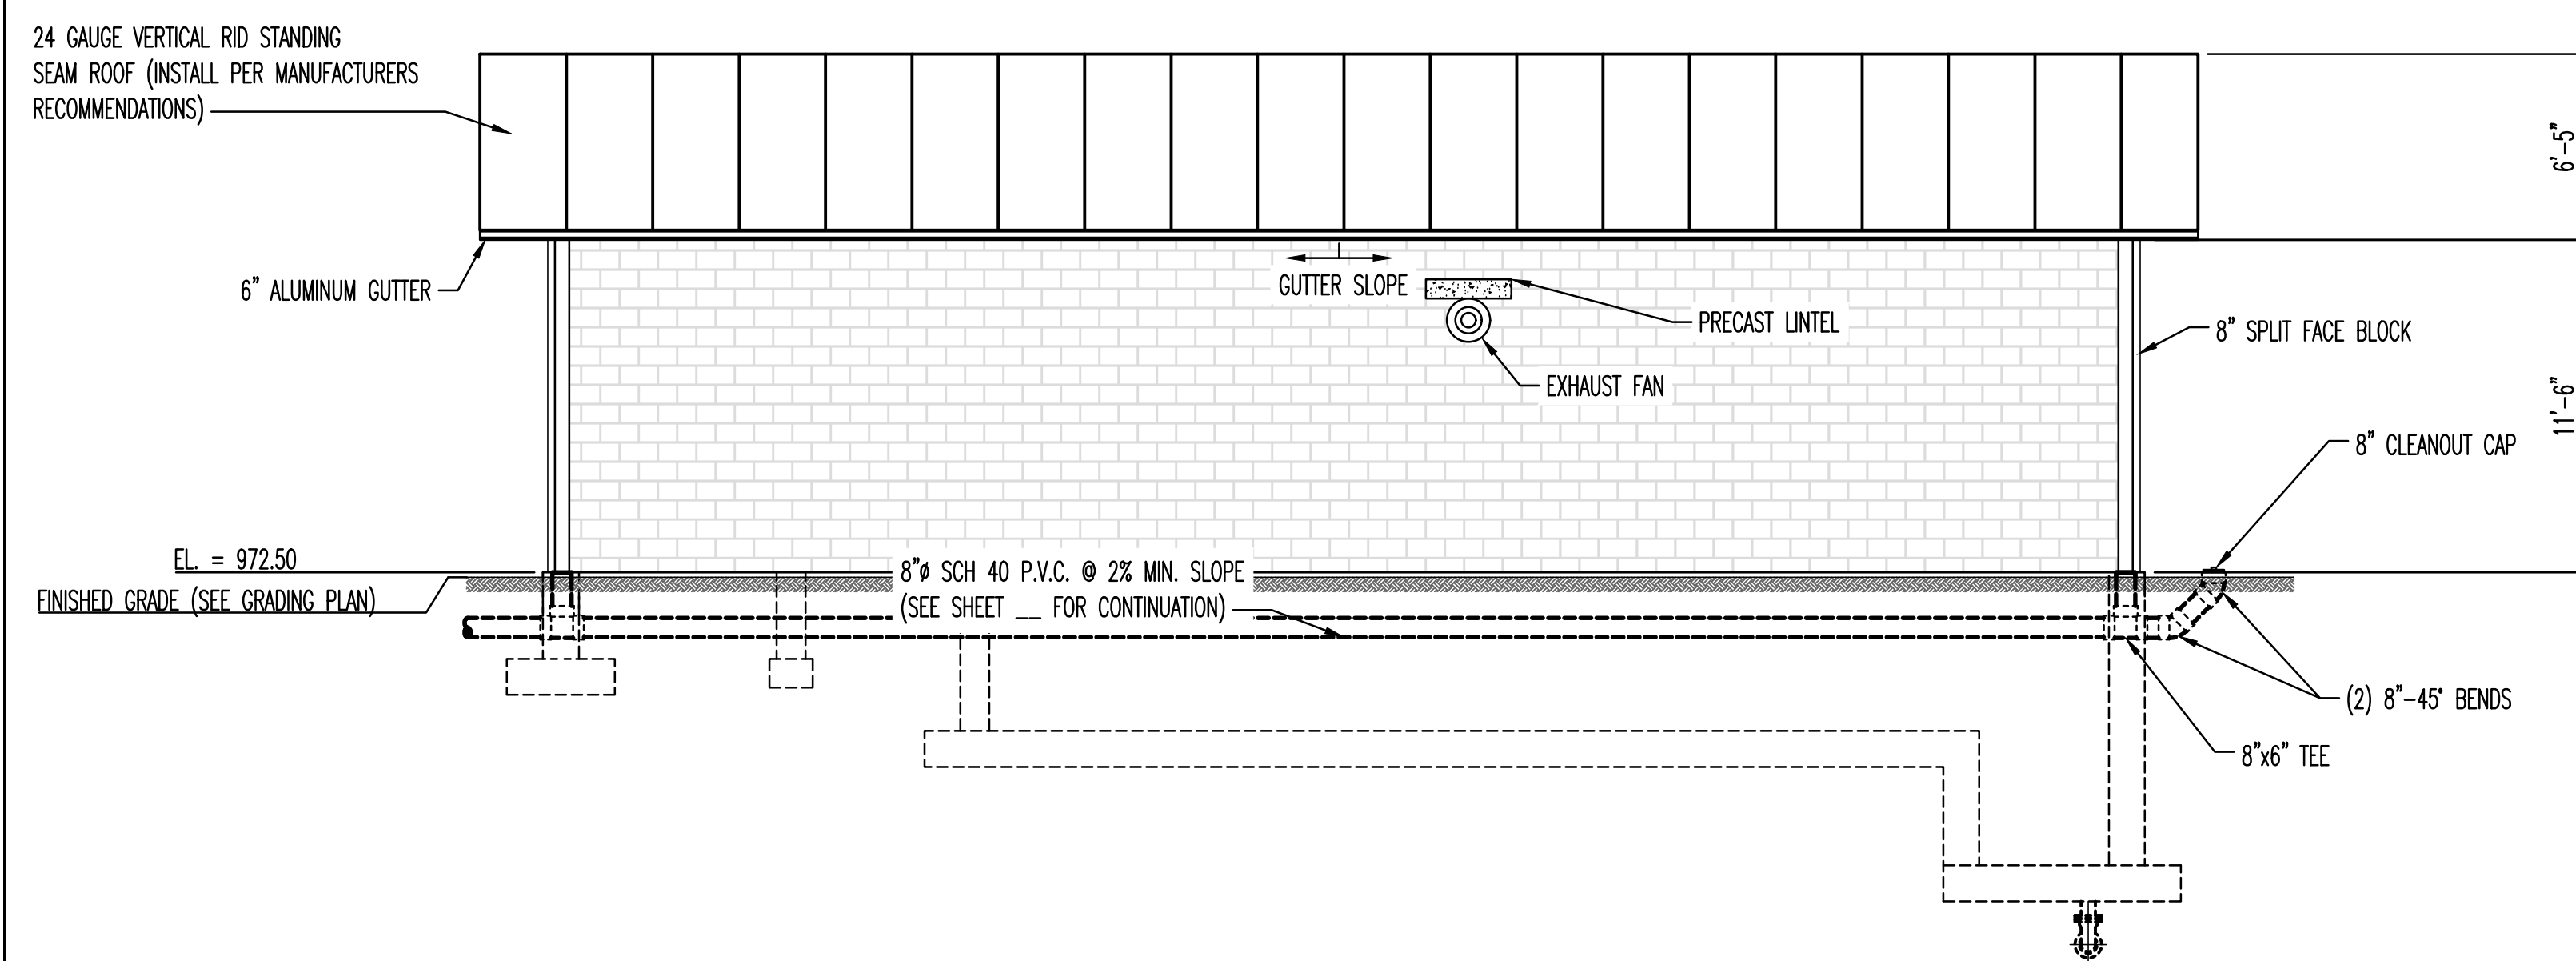

ELEVATION

SCALE: 3/16"=1'-0"


C
4

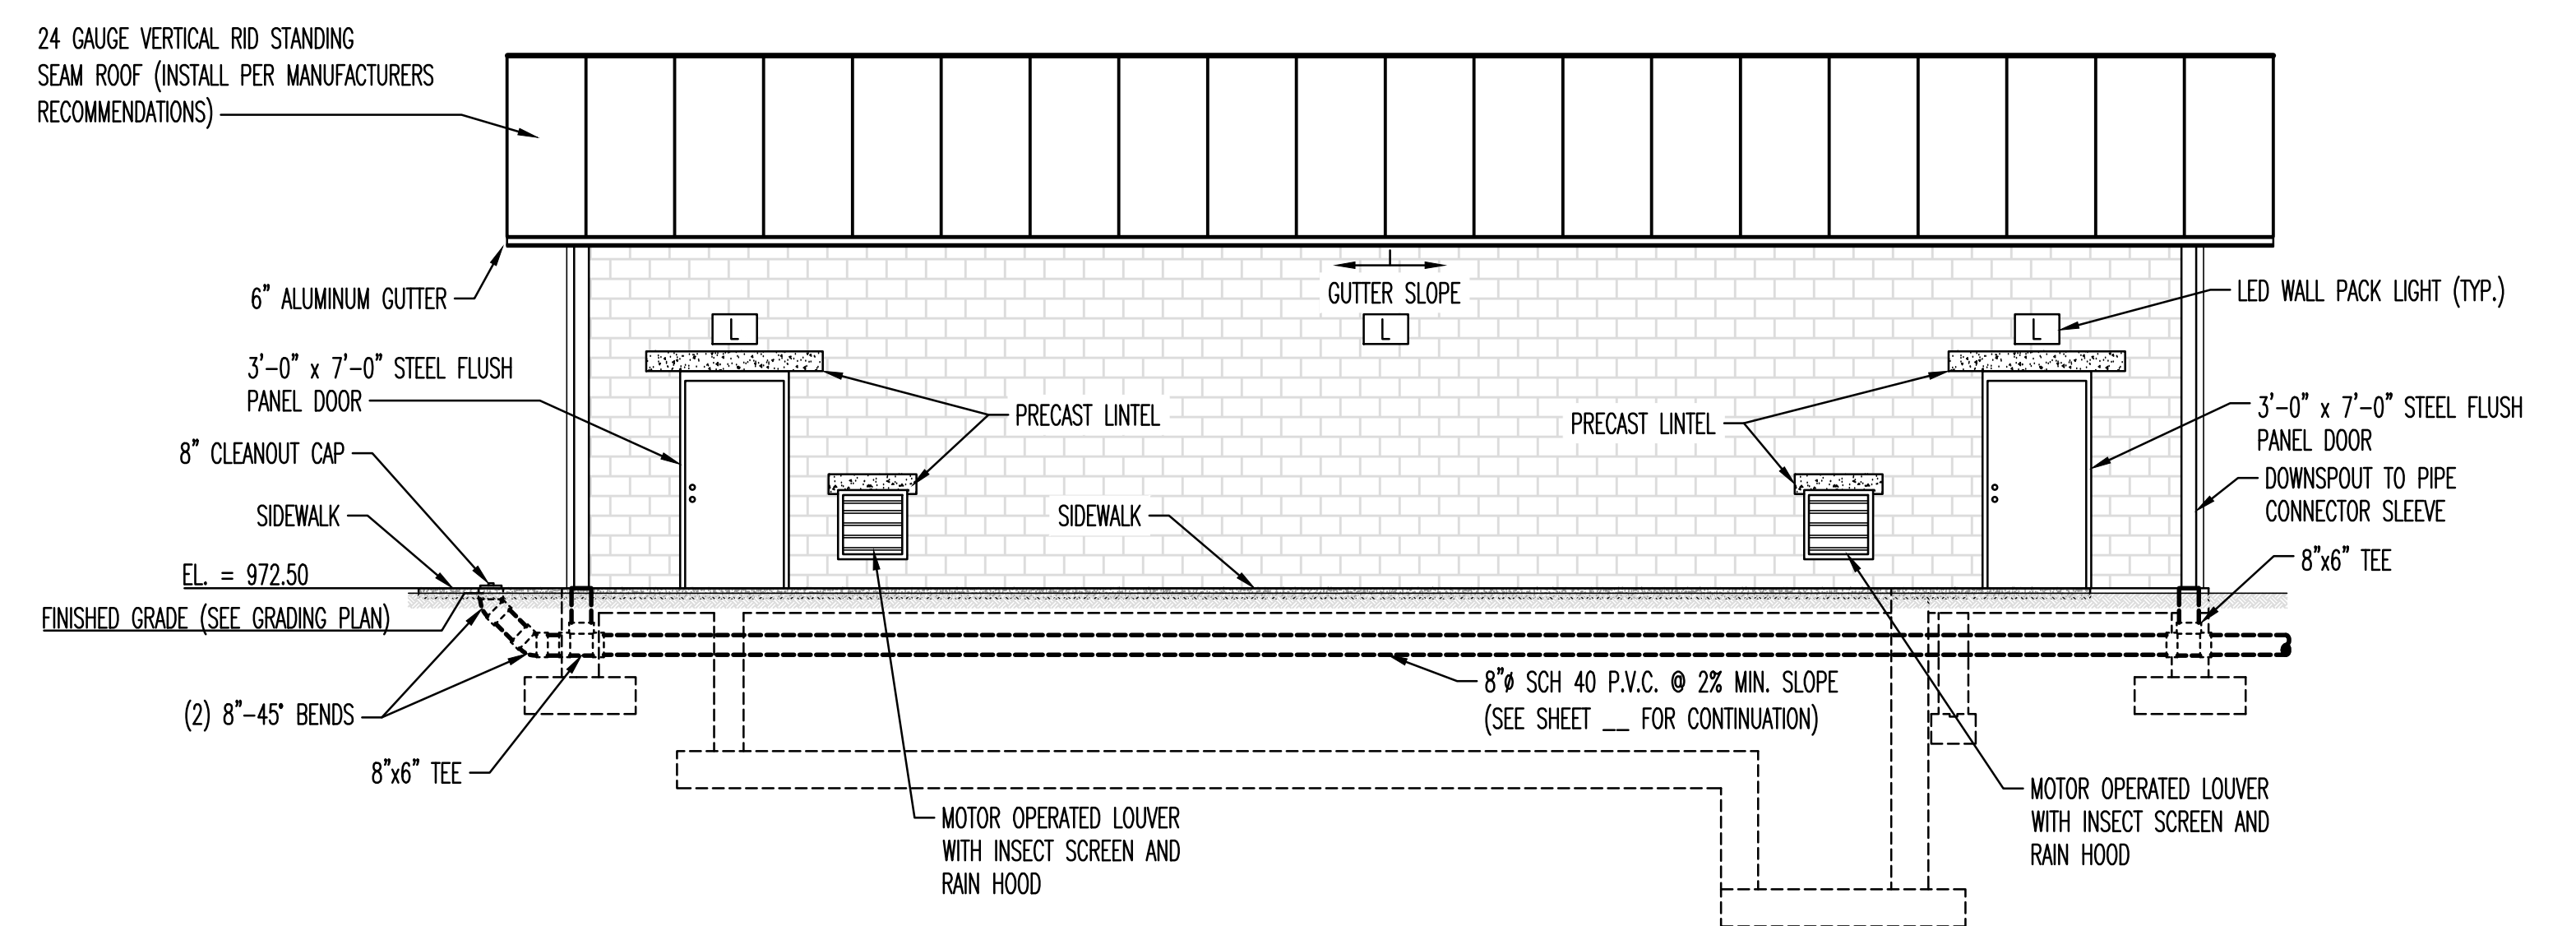

ELEVATION

SCALE: $3/16"=1'-0"$

D
4

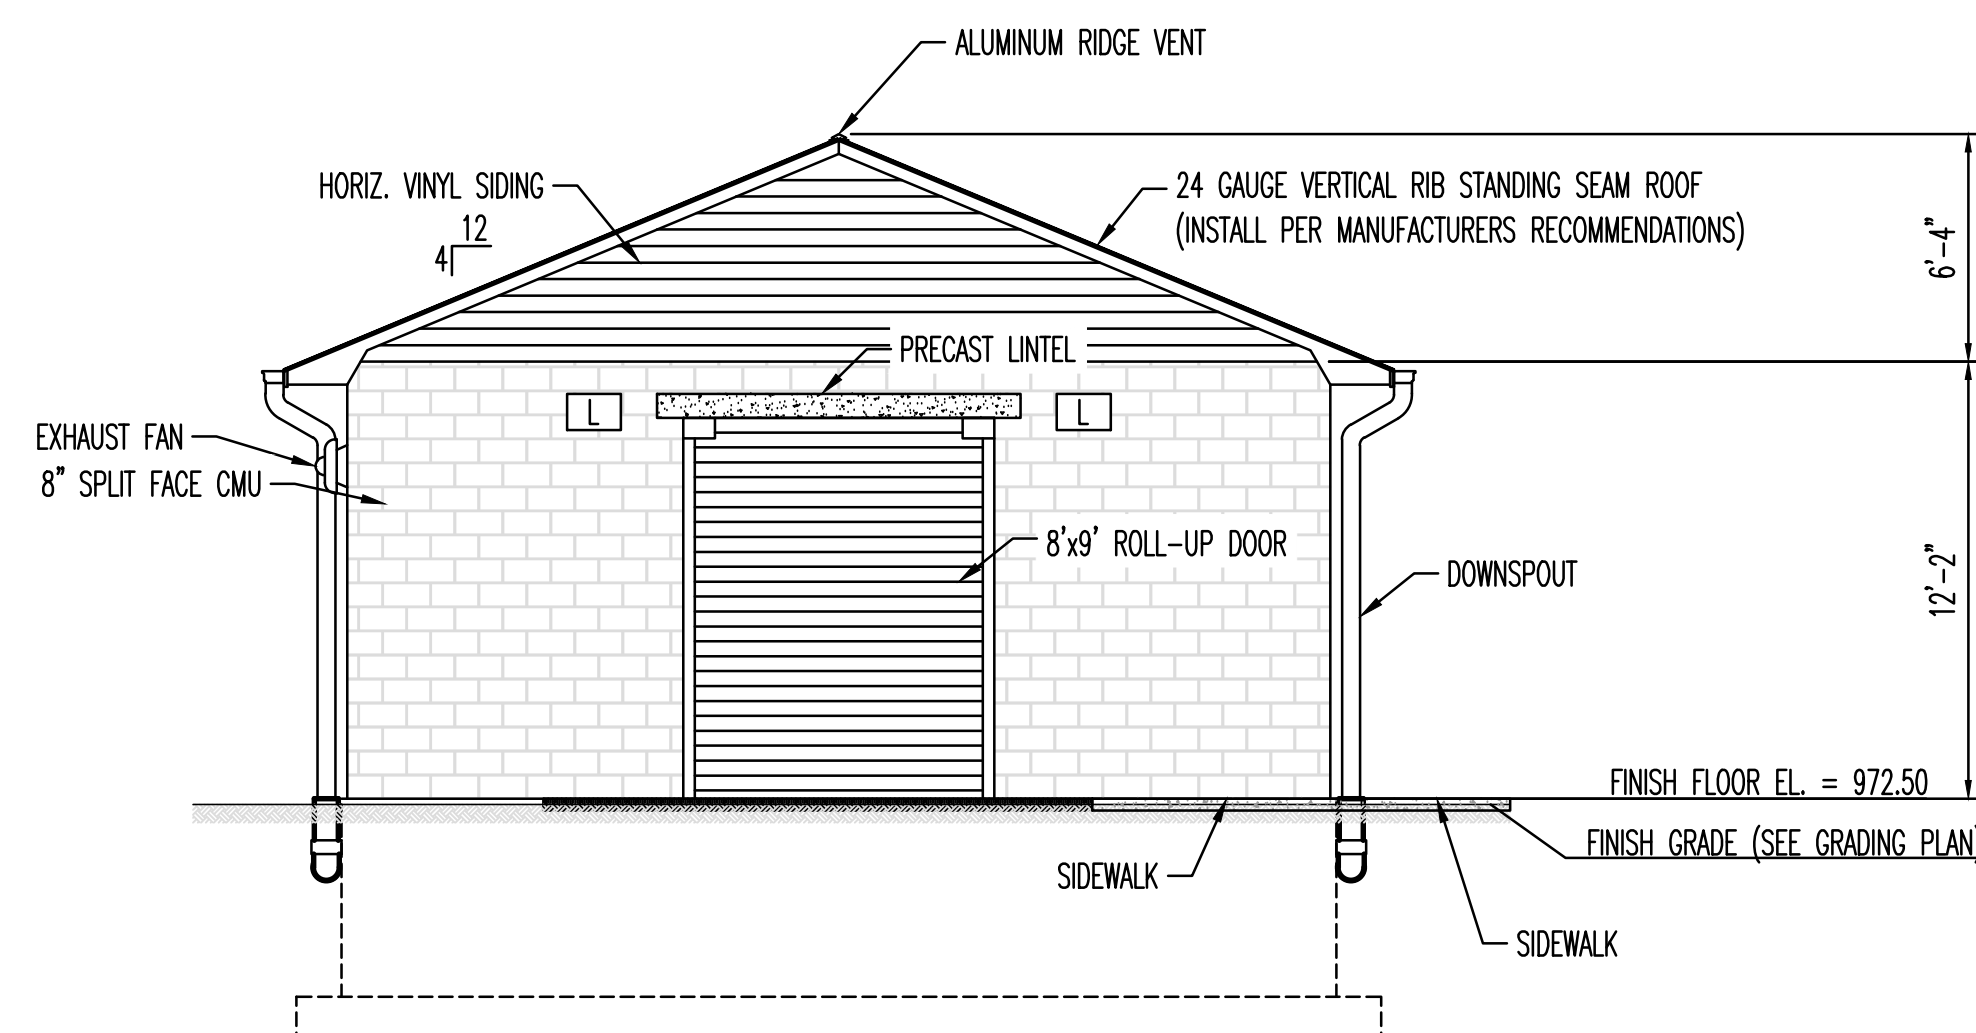

ELEVATION

SCALE: $3/16" = 1'-0"$

E
4

- NOTES:**
1. OWNER TO SELECT COLORS FOR THE FOLLOWING ITEMS:
 - A. SPLIT-FACE BLOCK
 - B. METAL ROOFING
 - C. GUTTERS & DOWNSPOUTS
 - D. PERSONNEL DOORS (PAINT)
 - E. ROLL-UP DOOR
 - F. VINYL SIDING & SOFFIT
 2. LINTEL FACE TO MATCH SPLIT FACE BLOCK.

10-I-19-UR

**FOR REVIEW
ONLY**

