
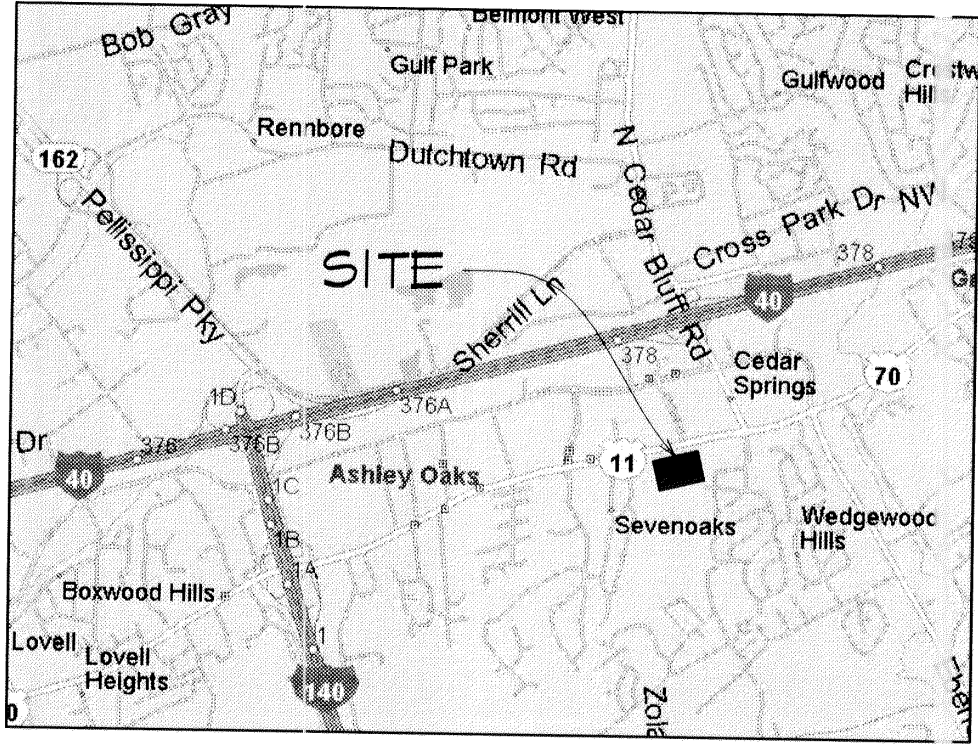


Tuesday, January 26, 2010 at 10:45am S:\MS\04\02023 Knoxville TN\Knox - 0402023\dwg\0402023.dwg lsd

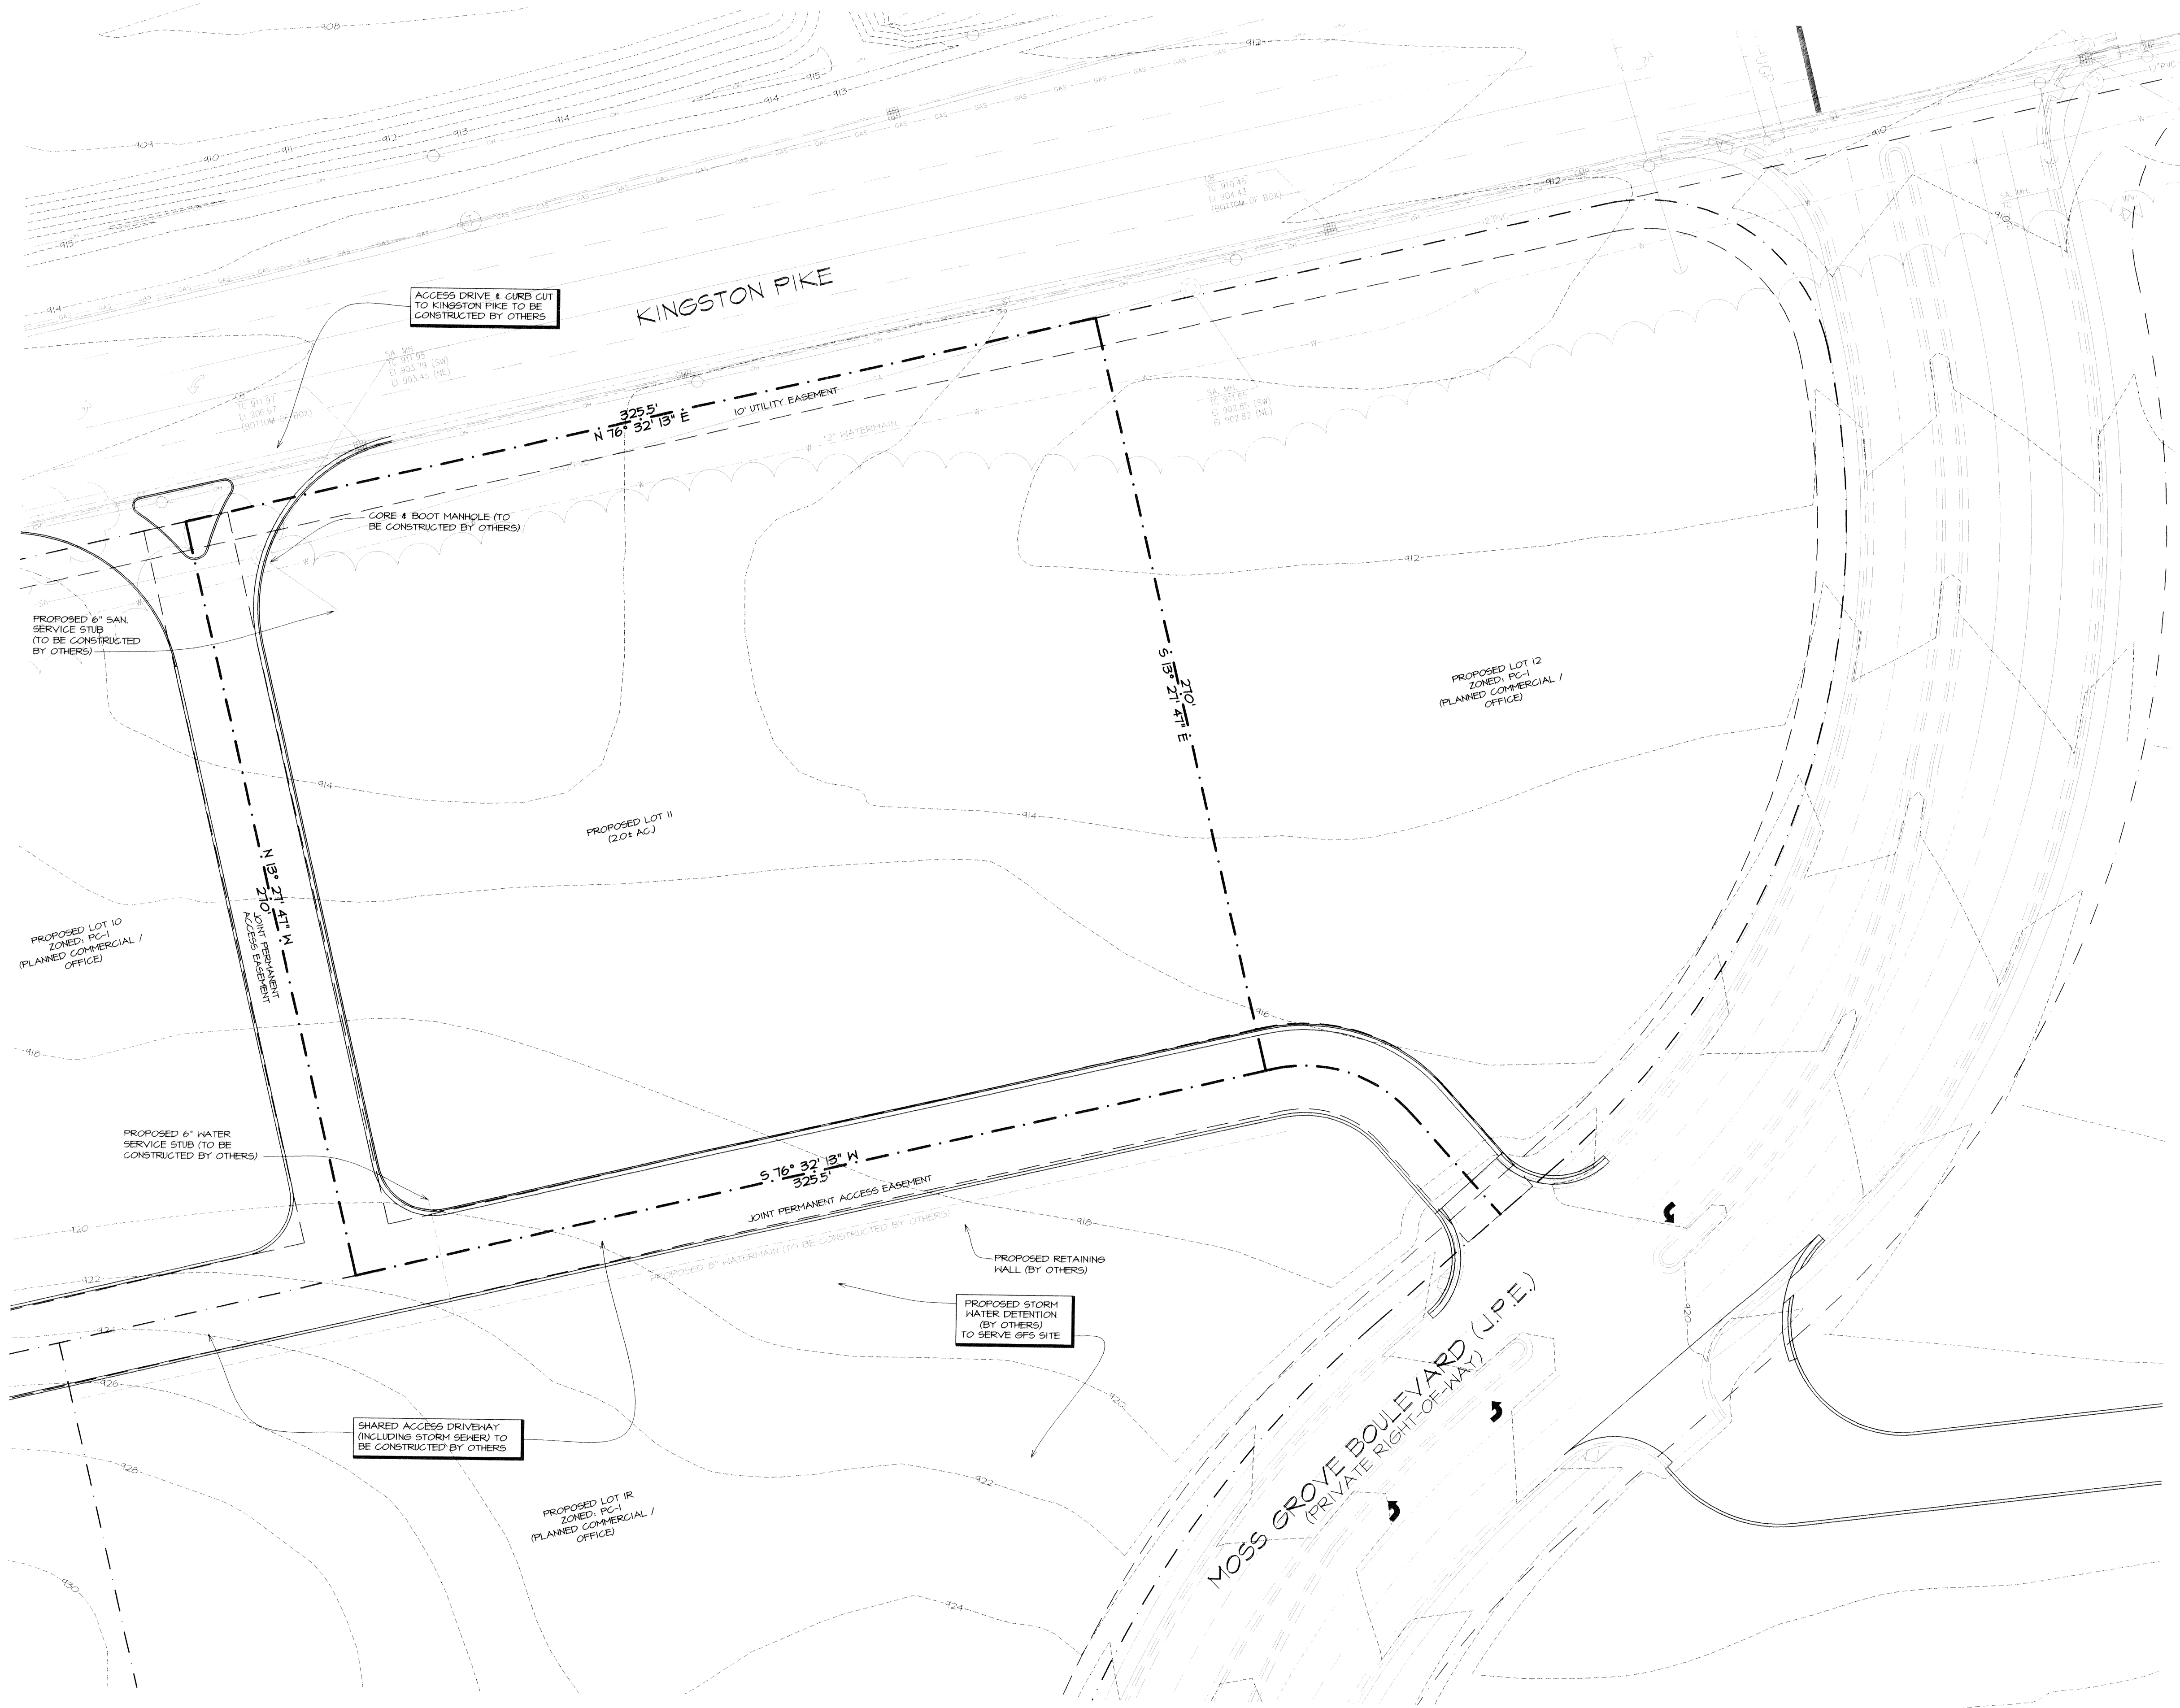


LOCATION MAP
SCALE: N.T.S.

LEGEND

ST	STORM SEWER LINE
SA	SANITARY SEWER LINE
UGP	UNDERGROUND POWER
X	FENCE LINE
G	UNDERGROUND GAS LINE
CMP	CATCH BASIN
RCP	CORRUGATED METAL PIPE
	REINFORCED CONCRETE PIPE
	ANCHOR WIRE
	POWER POLE
	LIGHT POLE
	WATER VALVE
	FIRE HYDRANT
	GAS METER
	WATER METER
	SIGN
	SANITARY MANHOLE
	WATER MANHOLE
	POWER MANHOLE
	TELEPHONE MANHOLE

UTILITY CONTACTS:	
CITY OF KNOXVILLE P.O. BOX 1631 400 MAIN STREET KNOXVILLE, TN 37902 TEL: 865-215-2000 WWW.CITYOFKNOXVILLE.TN.US.COM	POWER: KNOXVILLE UTILITY BOARD 445 S. GAY STREET KNOXVILLE, TN 37902 TEL: 865-524-2211
WATER: FIRST UTILITY DISTRICT 122 DURHAM ROAD KNOXVILLE, TN 37922 TEL: 865-466-4141 CONTACT: ROBERT BURNETT	GAS: KNOXVILLE UTILITY BOARD 445 S. GAY STREET KNOXVILLE, TN 37902 TEL: 865-524-2211
SEWER: FIRST UTILITY DISTRICT 122 DURHAM ROAD KNOXVILLE, TN 37922 TEL: 865-466-4141 CONTACT: ROBERT BURNETT	

SURVEY PROVIDED BY:
CANNON & CANNON, INC.
2550 KINGSTON PIKE
KNOXVILLE, TN 37914
(865) 670-8555
WWW.CANNON-CANNON.COM

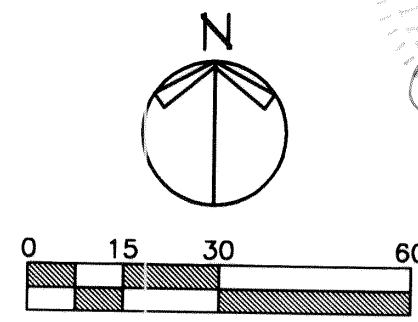

Tennessee One Call System
Stop - Call Before You Dig! 1-800-351-1111

NOTE:
ALL UTILITIES SHOWN ARE APPROXIMATE
LOCATIONS FROM FIELD DATA AND
AVAILABLE INFORMATION. THEY SHOULD NOT
BE INTERPRETED AS EXACT LOCATIONS NOR
SHOULD THEY BE ASSUMED TO BE THE ONLY
UTILITIES IN THE AREA.

NOT FOR CONSTRUCTION

ARCHITECTS • CIVIL ENGINEERS

paradigm
design

550 3 MILE N.W.

SUITE B

GRAND RAPIDS, MI 49544

PHONE (616) 785 • 5656

FAX (616) 785 • 5657

WEB PARADIGMAE.COM

PROJECT

GORDON
FOOD
SERVICE
MARKETPLACE
STORE

(PART OF SHERRILL HILLS
DEVELOPMENT)

9320 KINGSTON PIKE (APPROX.)
KNOXVILLE, TN

GFS
MARKETPLACE, LLC

420 50TH STREET SW
GRAND RAPIDS, MICHIGAN

RELEASE DATE

12-17-09 DESIGN REVIEW

12-22-09 DESIGN REVIEW

1-26-10 REVIEW PER CITY STAFF
REVIEW MEETING

PROJECT


0902021

SHEET

0100

EXISTING CONDITIONS

Tuesday, January 26, 2021 at 12:31pm 5:46PM/09/02/2021 Knoxville TN/Civil - 09/02/2021/09/02/2021.dwg uid

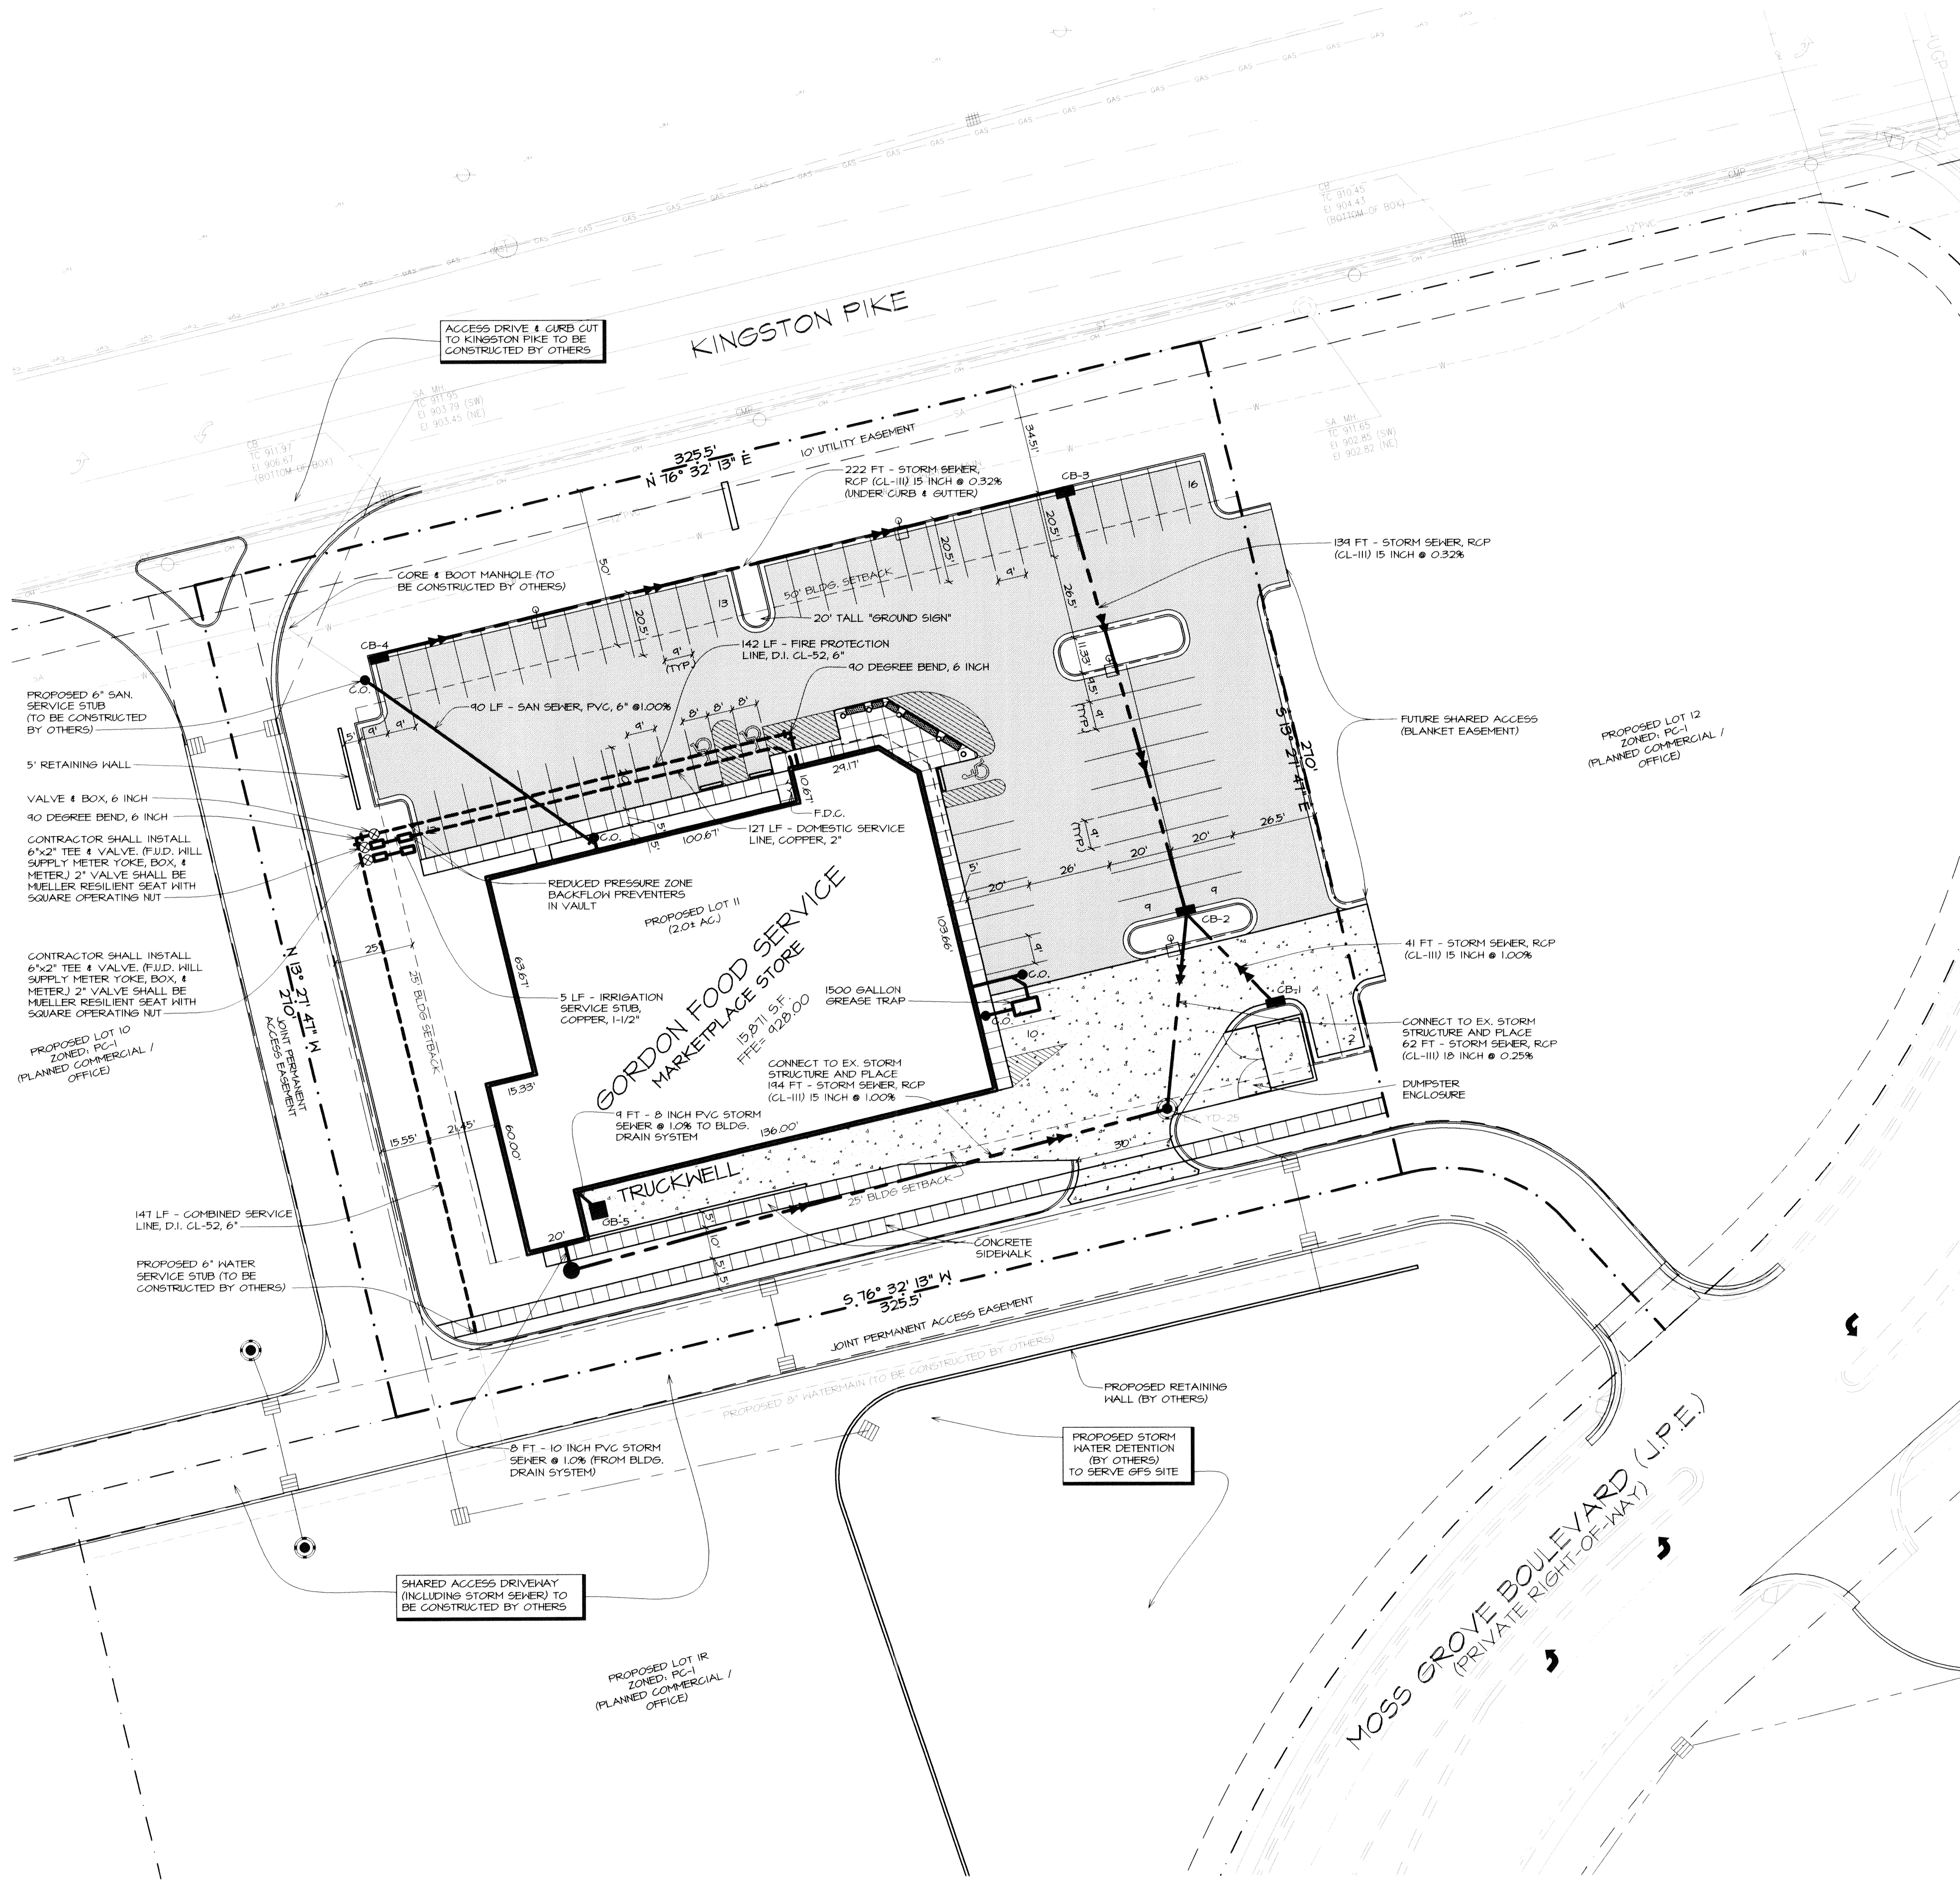

LEGEND	
ST	STORM SEWER LINE
SA	SANITARY SEWER LINE
UGP	UNDERGROUND POWER
F	FENCE LINE
G	UNDERGROUND GAS LINE
CB	CATCH BASIN
CMP	CORRUGATED METAL PIPE
RCP	REINFORCED CONCRETE PIPE
A	ANCHOR BIRE
P	POWER POLE
L	LIGHT POLE
V	WATER VALVE
H	FIRE HYDRANT
M	GAS METER
W	WATER METER
S	SIGN
SM	SANITARY MANHOLE
WM	WATER MANHOLE
PM	POWER MANHOLE
TM	TELEPHONE MANHOLE

LAYOUT & UTILITY LEGEND	
STANDARD CURB AND GUTTER	STANDARD CURB AND GUTTER
INVERTED CURB AND GUTTER	INVERTED CURB AND GUTTER
SANITARY SEWER	SANITARY SEWER
STORM SEWER	STORM SEWER
WATERMAIN	WATERMAIN
CONCRETE SIDEWALK	CONCRETE SIDEWALK
CONCRETE PAVEMENT	CONCRETE PAVEMENT
HEAVY DUTY PAVEMENT SECTION	HEAVY DUTY PAVEMENT SECTION
STANDARD DUTY PAVEMENT SECTION	STANDARD DUTY PAVEMENT SECTION
CATCH BASIN	CATCH BASIN
MANHOLE	MANHOLE
C.O.	SANITARY CLEANOUT
SIGN AND POST	SIGN AND POST
TRANSFORMER PAD	TRANSFORMER PAD
PROPOSED LIGHT POLE - (REF. SITE LIGHTING PLAN)	PROPOSED LIGHT POLE - (REF. SITE LIGHTING PLAN)

PROPOSED STRUCTURE TABLE	
CB-1, 48" DIA. CATCH BASIN TDOT NO. 12 CB (D-CB-12RA) RIM: 426.00 15' (N) INV.: 422.50	CB-5, 48" DIA. CATCH BASIN TDOT NO. 12 CB (D-CB-12RA) RIM: 424.00 15' (E) INV.: 420.50
CB-2, 60" DIA. CATCH BASIN TDOT NO. 12 CB (D-CB-12RB) RIM: 426.25 15' (N) INV.: 421.11 15' (SE) INV.: 422.34 18' (SW) INV.: 420.95	ST-6, 48" DIA. MANHOLE TDOT NO. 12 CB (D-CB-12RA) RIM: 428.00 10' (N) INV.: 423.24 15' (E) INV.: 423.43
CB-3, 48" DIA. CATCH BASIN TDOT NO. 12 CB (D-CB-12RA) RIM: 425.44 15' (N) INV.: 421.12 15' (S) INV.: 421.56	TD-25, 24" DIAM. DRAIN TDOT 1278 (D-CB-LRB) RIM: 426.58 15' (N) INV.: 421.44 18' (NE) INV.: 421.40 24' (SE) INV.: 421.33
CB-4, 48" DIA. CATCH BASIN TDOT NO. 12 CB (D-CB-12RA) RIM: 425.43 15' (E) INV.: 422.43	

SITE DATA	
PROPOSED SITE, 2.0+ ACRES ZONED: PC-1 (PLANNED COMM/OFFICE)	
SETBACKS FRONT: 50' STREET SIDE: 25' INTERIOR SIDE: NONE REAR: 25'	
PARKING REQUIRED: 71 SPACES (43/1,000 SF G.F.A.) PROVIDED: 71 SPACES (INCLUDING 3 BF SPACES) 30,240 SF PARKING 5,270 SF LOADING	

UTILITY CONTACTS:	
CITY OF KNOXVILLE P.O. BOX 1631 400 MAIN STREET KNOXVILLE, TN 37902 TEL: 865-205-2000 WWW.CITYKNOXVILLE.TN.US/COM	POWER: KNOXVILLE UTILITY BOARD 445 S. GAY STREET KNOXVILLE, TN 37902 TEL: 865-524-2911
WATER: FIRST UTILITY DISTRICT 122 DURNHOOD ROAD KNOXVILLE, TN 37922 TEL: 865-966-4741 CONTACT: ROBERT BURNETT	GAS: KNOXVILLE UTILITY BOARD 445 S. GAY STREET KNOXVILLE, TN 37902 TEL: 865-524-2911
SEWER: FIRST UTILITY DISTRICT 122 DURNHOOD ROAD KNOXVILLE, TN 37922 TEL: 865-966-4741 CONTACT: ROBERT BURNETT	

GENERAL SITE NOTES

REFER TO ARCHITECTURAL PLANS FOR DETAILS OF CONCRETE SIDEWALK AROUND BUILDING, CONCRETE TRUCK HELL, BOLLARD DETAIL (GPS ONLY), AND CONCRETE DUMPSTER PAD.

REFER TO ARCHITECTURAL FOUNDATION PLAN FOR DETAILING OF BUILDING AND EXACT BUILDING DIMENSIONS.

REFER TO LANDSCAPE PLAN FOR ACTUAL LOCATION OF SIGNS AND FOR RESTORATION OF ALL NON PAVED SURFACES.

REFER TO SECTION 02230 OF THE SPECIFICATIONS BOOK FOR SITE CLEARING WORK.

REFER TO SECTION 02260 OF THE SPECIFICATIONS BOOK FOR EXCAVATION SUPPORT AND PROTECTION OF EXISTING UTILITIES AND STRUCTURES.

REFER TO SPECIFICATIONS FOR SITE "RECORD DRAINGS" SUBMITTAL REQUIREMENTS.

UPON AWARD OF CONTRACT, CONTRACTOR WILL BE RESPONSIBLE TO CHECK WITH ENGINEER AND JURISDICTION ON STATUS OF THE PERMITS LISTED ABOVE.

CONTRACTOR IS RESPONSIBLE TO OBTAIN ALL SITE RELATED PERMITS NOT BEING OBTAINED BY THE OWNER. CONTRACTOR IS REQUIRED TO COMPLETE THE APPLICATION AND SUBMIT NECESSARY DRAWINGS, FEES, ETC., TO THE APPROPRIATE JURISDICTION. CONTRACTOR SHALL PAY ALL FEES RELATED TO PERMITS AND SECURE PERMITS IN HIS NAME.

CONTRACTOR IS RESPONSIBLE TO COORDINATE ALL SITE UTILITY CONNECTIONS AND INSPECTIONS WITH THE PROPER JURISDICTION AND PAY ALL ASSOCIATED FEES.

THE CONTRACTOR SHALL FIELD VERIFY LOCATION AND ELEVATION OF EXISTING WATER, SANITARY SEWER, AND STORM SEWER CROSSINGS AND CONNECTION POINTS PRIOR TO CONSTRUCTION. CONTACT ENGINEER WITH ANY DISCREPANCIES.

ALL DIMENSIONS SHOWN TO CONCRETE CURB AND GUTTER ARE TO BACK OF CURB UNLESS OTHERWISE NOTED.

CONCRETE GUTTER PAN TO TIP IN THE DIRECTION OF THE ADJACENT PAVEMENT.

ALL PAVEMENT MARKINGS SHALL BE 4" WIDE. STANDARD PARKING SPACES SHALL BE MARKED IN WHITE AND BARRIER FREE SPACES IN BLUE. EACH BARRIER FREE SPACE SHALL BE PROVIDED WITH A PAINTED PAVEMENT SYMBOL, A PRECAST CONCRETE BARRIER BLOCK AND A SIGN PER THE MANUAL OF UNIFORM TRAFFIC CONTROLS.

REFERENCE SOILS REPORT IN SPECIFICATION BOOK FOR BORING LOGS AND PREPARATION AND CONSTRUCTION PROCEDURES FOR SUB-BASE AND DESIGN SECTION OF ALL PAVED AREAS.

ALL TDOT REFERENCES ARE TO THE 2006 EDITION.

GENERAL PRIVATE UTILITY NOTES

PROPOSED PRIVATE UTILITY SERVICE AS SHOWN ARE SCHEMATIC ONLY. ACTUAL LOCATION TO BE COORDINATED WITH INDIVIDUAL UTILITY COMPANY AND APPROVED BY OWNER.

CONTRACTOR SHALL COORDINATE LOCATION OF ALL PRIVATE UTILITIES (i.e. GAS, ELECTRIC, TELEPHONE...) WITH THE LOCAL UTILITY COMPANIES AND THE MECHANICAL DRAWINGS. COORDINATE ALL PRIVATE UTILITY LOCATIONS WITH ALL SUB-SURFACE SITE UTILITIES SHOWN ON THIS PLAN.

GENERAL STORM SEWER NOTES

STORM SEWER PIPE SHALL BE REINFORCED CONCRETE PER ASTM C76 CLASS III WALL B. JOINTS SHALL BE RUBBER O-RINGS PER ASTM C443.

MATERIALS, INSTALLATION & TESTING OF THE STORM SEWER SYSTEM SHALL CONFORM TO CITY OF KNOXVILLE STANDARDS.

GENERAL SANITARY SERVICE NOTES

SITE CONTRACTOR TO END SANITARY LATERAL WITH A CLEAN-OUT AND TEMPORARY CAP AT 4' FROM BUILDING. COORDINATE CONNECTION WITH BUILDING PLUMBING CONTRACTOR.

SANITARY SEWER SERVICE LATERAL AND FITTINGS SHALL BE SCHED. 40 PER ASTM D-2665.

MATERIALS, INSTALLATION AND TESTING OF SANITARY SEWER SERVICES SHALL CONFORM TO FIRST UTILITY BOARD STANDARDS.

GENERAL WATER SERVICE NOTES


SITE CONTRACTOR TO END WATER SERVICE(S) 12" ABOVE FINISHED FLOOR, INSIDE BUILDING AND INSTALL TEMPORARY CAP. COORDINATE WITH BUILDING PLUMBING CONTRACTOR.

FIRE PROTECTION LINE AND COMBINED SERVICE LINE SHALL BE DUCTILE IRON PER ANSI/AWWA C151/A21.5, THICKNESS CLASS 52 PER ANSI/AWWA C110/A21.2. FITTINGS SHALL BE DUCTILE IRON PER ANSI/AWWA C110/A21.10, PRESSURE CLASS 350.

DOMESTIC SERVICE SHALL BE COPPER, TYPE K, ANNEALED AND SOFT TEMPER PER ASTM B-88. FITTINGS SHALL CONFORM TO ASTM B-88.

MINIMUM DEPTH OF BURY SHALL BE 48".

MATERIALS, INSTALLATION AND TESTING OF WATER SERVICE LINES SHALL CONFORM TO FIRST UTILITY BOARD STANDARDS AND THE STATE PLUMBING CODE.

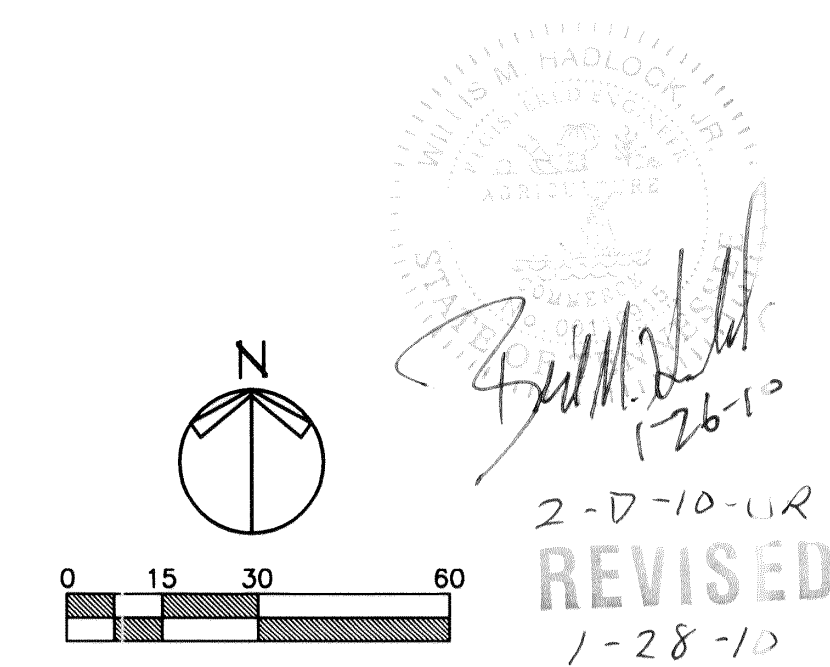

Tennessee One Call System
Stop - Call Before You Dig! 1-800-351-1111

NOTE:
ALL UTILITIES SHOWN ARE APPROXIMATE LOCATIONS FROM FIELD DATA AND AVAILABLE INFORMATION. THEY SHOULD NOT BE INTERPRETED AS EXACT LOCATIONS NOR SHOULD THEY BE ASSUMED TO BE THE ONLY UTILITIES IN THE AREA.

NOT FOR CONSTRUCTION

ARCHITECTS • CIVIL ENGINEERS

p
d

paradigm
design

550 3 MILE N.W.
SUITE B
GRAND RAPIDS, MI 49544
PHONE (616) 785 • 5656
FAX (616) 785 • 5657
WEB PARADIGMAE.COM

PROJECT

GORDON
FOOD
SERVICE
MARKETPLACE
STORE

(PART OF SHERRILL HILLS
DEVELOPMENT)

9320 KINGSTON PIKE (APPROX.)
KNOXVILLE, TN

GFS
MARKETPLACE, LLC
420 5TH STREET SW
GRAND RAPIDS, MICHIGAN

RELEASE DATE


12-17-09 OWNER REVIEW
12-22-09 USE ON REVIEW
1-26-11 REV PER CITY STAFF
REVIEW MEETING

PROJECT

0902021

SHEET

C 101

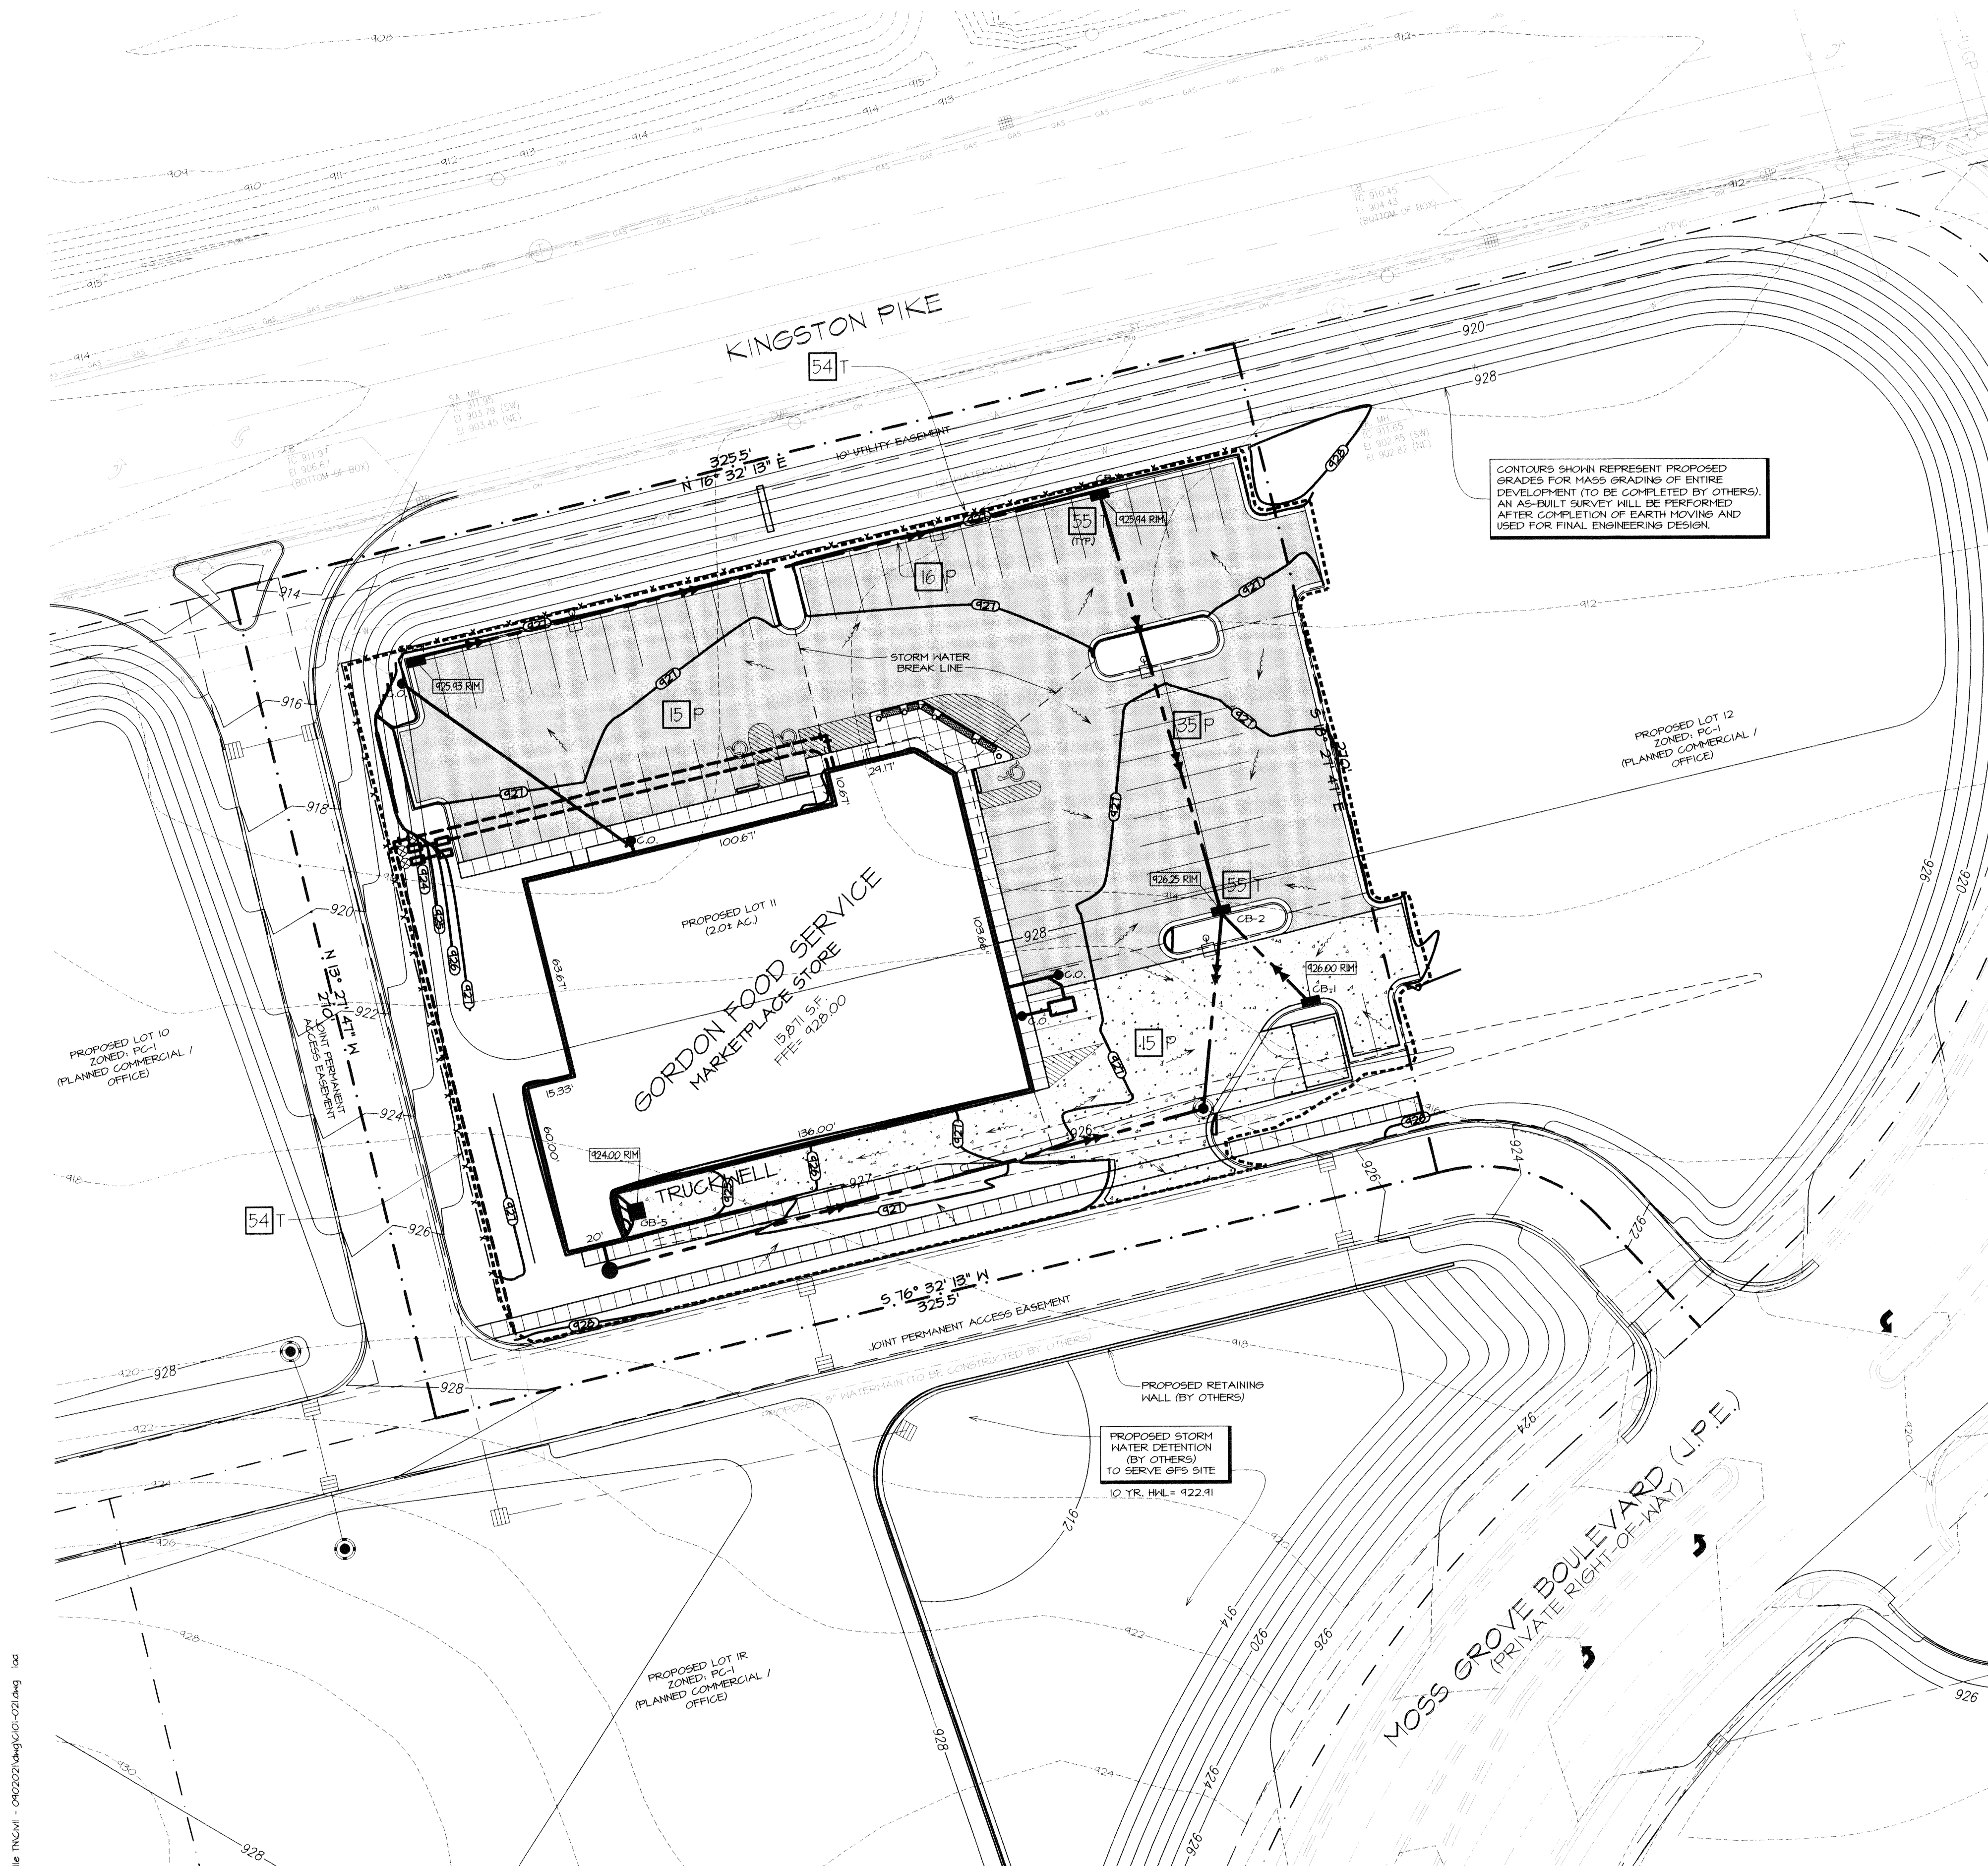

CONTOURS SHOWN REPRESENT PROPOSED GRADES FOR MASS GRADING OF ENTIRE DEVELOPMENT (TO BE COMPLETED BY OTHERS). AN AS-BUILT SURVEY WILL BE PERFORMED AFTER COMPLETION OF EARTH MOVING AND USED FOR FINAL ENGINEERING DESIGN.

PROPOSED STRUCTURE TABLE	
CB-1, 48" DIA. CATCH BASIN TDOT NO. 12 CB (D-CB-12RA) RIM: 426.00 15" (N) INV: 422.50	CB-5, 48" DIA. CATCH BASIN TDOT NO. 12 CB (D-CB-12RA) RIM: 424.00 15" (E) INV: 420.50
CB-2, 60" DIA. CATCH BASIN TDOT NO. 12 CB (D-CB-12RB) RIM: 426.25 15" (N) INV: 421.11 15" (SE) INV: 422.34 10" (SW) INV: 420.45	ST-6, 48" DIA. MANHOLE TDOT NO. 12 CB (D-CB-12RA) RIM: 426.00 10" (N) INV: 423.54 15" (E) INV: 423.43
CB-3, 48" DIA. CATCH BASIN TDOT NO. 12 CB (D-CB-12RA) RIM: 425.94 15" (N) INV: 421.12 15" (S) INV: 421.56	TD-25, 24" DIA. YARD DRAIN TDOT NO. 12 CB (D-CB-12RB) RIM: 426.58 15" (N) INV: 421.44 10" (NE) INV: 421.40 24" (SE) INV: 421.33
CB-4, 48" DIA. CATCH BASIN TDOT NO. 12 CB (D-CB-12RA) RIM: 425.93 15" (E) INV: 422.43	

UTILITY CONTACTS:

CITY OF KNOXVILLE
P.O. BOX 1051
400 MAIN STREET
KNOXVILLE, TN 37902
TEL: 865-215-2000
WWW.CITYOFKNOXVILLE.TN.US/CITY

POWER:
KNOXVILLE UTILITY BOARD
445 S. GAY STREET
KNOXVILLE, TN 37902
TEL: 865-524-2411

WATER:
FIRST UTILITY DISTRICT
122 DURNWOOD ROAD
KNOXVILLE, TN 37922
TEL: 865-966-4741
CONTACT: ROBERT BURNETT

SEWER:
FIRST UTILITY DISTRICT
122 DURNWOOD ROAD
KNOXVILLE, TN 37922
TEL: 865-966-4741
CONTACT: ROBERT BURNETT

CONSTRUCTION SEQUENCE	YEAR: 2010											
	JAN	FEB	MAR	APR	MAY	JUN	JUL	AUG	SEP	OCT	NOV	DEC
STRIPPING & STOCKPILING TOPSOIL												
ROUGH GRADING SEDIMENT CONTROL												
TEMPORARY CONTROL MEASURES												
STORM UTILITIES												
TEMPORARY CONSTRUCTION ROADS												
PERMANENT CONTROL MEASURES												
FOUNDATION BUILDING CONSTRUCTION												
SITE CONSTRUCTION												
FINISH GRADING												
LANDSCAPING												

GENERAL CONTRACTOR SHALL COMPLETE CONSTRUCTION SEQUENCE SCHEDULE WHEN MAKING APPLICATION FOR SOIL EROSION CONTROL PERMIT

LEGEND	
ST	STORM SEWER LINE
SA	SANITARY SEWER LINE
UGP	UNDERGROUND POWER
F	FENCE LINE
G	UNDERGROUND GAS LINE
CMP	CATCH BASIN
RCP	CONCRETE METAL PIPE
RCP	REINFORCED CONCRETE PIPE
A	ANCHOR HIRE
P	POWER POLE
L	LIGHT POLE
V	WATER VALVE
F	FIRE HYDRANT
M	GAS METER
M	WATER METER
S	SEWER
M	SANITARY MANHOLE
M	WATER MANHOLE
P	POWER MANHOLE
T	TELEPHONE MANHOLE

GRADING AND SOIL EROSION & SEDIMENTATION CONTROL LEGEND	
123.00	PROPOSED SPOT GRADE
---	SURFACE WATER FLOW DIRECTION
BIT	PROPOSED BITUMINOUS GRADE
CON	PROPOSED CONCRETE GRADE
FW	PROPOSED FRONT OF WALK GRADE
BW	PROPOSED BACK OF WALK GRADE
RIM	PROPOSED CATCH BASIN FLOWLINE GRADE
TC	TOP OF CURB GRADE
FL	FLOOR LINE GRADE
MATCH EX.	MATCH EXISTING ELEVATION
# P	PERMANENT SOIL EROSION & SEDIMENTATION CONTROL MEASURE
# T	TEMPORARY SOIL EROSION & SEDIMENTATION CONTROL MEASURE
TYP. MEASURE	
---	STANDARD CURB AND GUTTER
---	SANITARY SEWER
---	STORM SEWER
---	WATERMAIN
---	STORM WATER BREAK LINE
---	PROPOSED CONTOUR
---	EXISTING CONTOUR
---	SILT FENCE
---	GRADING LIMITS
---	EROSION CONTROL BLANKET
---	CONCRETE SIDEWALK
---	CONCRETE PAVEMENT
---	HEAVY DUTY PAVEMENT SECTION
---	STANDARD DUTY PAVEMENT SECTION
---	CATCH BASIN
---	MANHOLE
---	SANITARY CLEANOUT
---	SIGN AND POST
---	TRANSFORMER PAD - REF. MECHANICAL DRAWINGS
---	PROPOSED LIGHT POLE - REF. SITE LIGHTING PLAN

UNIFIED KEYING SYSTEM	
SOIL EROSION AND SEDIMENTATION CONTROL MEASURES	
6	HYDROSEED UNDER EROSION CONTROL BLANKET
7	HYDRO SEEDING
8	SODDING
15	PAVING
16	CURB & GUTTER
35	STORM SEWER
54	GEOTEXTILE SILT FENCE
55	GEOTEXTILE INLET FILTER

0 15 30 60

2-D-10 UR
REVISED
1-28-10

Tennessee One Call System
Stop - Call Before You Dig! 1-800-351-1111

ARCHITECTS • CIVIL ENGINEERS

paradigm design

550 3 MILE N.W.
SUITE B
GRAND RAPIDS, MI 49544

PHONE: (616) 785 - 5656
FAX: (616) 785 - 5657
WEB: PARADIGMAE.COM

PROJECT

GORDON FOOD SERVICE MARKETPLACE STORE

(PART OF SHERRILL HILLS DEVELOPMENT)

9320 KINGSTON PIKE (APPROX.)
KNOXVILLE, TN

GFS MARKETPLACE, LLC

420 5TH STREET SW
GRAND RAPIDS, MICHIGAN

RELEASE DATE

12-17-09 OWNER REVIEW
12-22-09 USE ON REVIEW
1-26-10 REV PER CITY STAFF REVIEW MEETING





PROJECT

0902021

SHEET

C 102

SITE GRADING

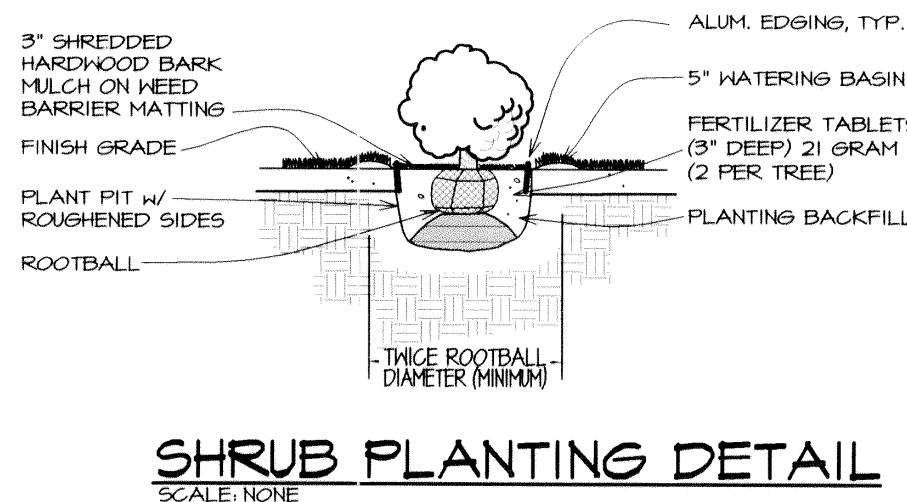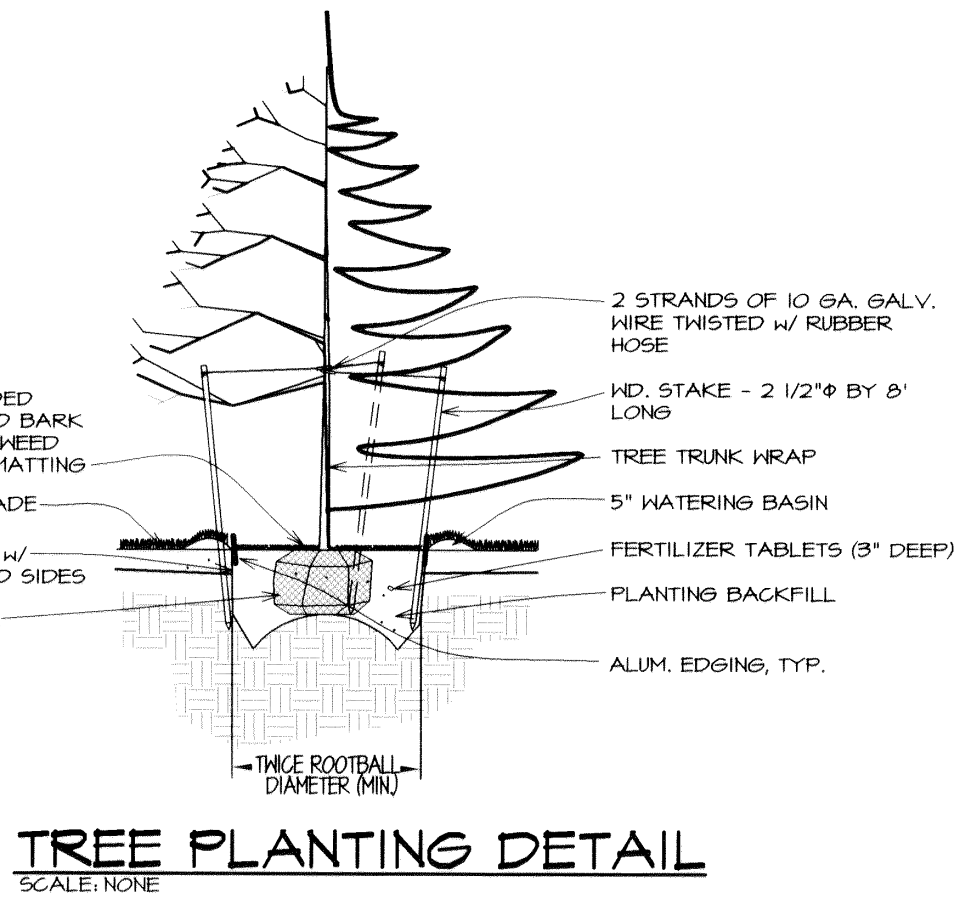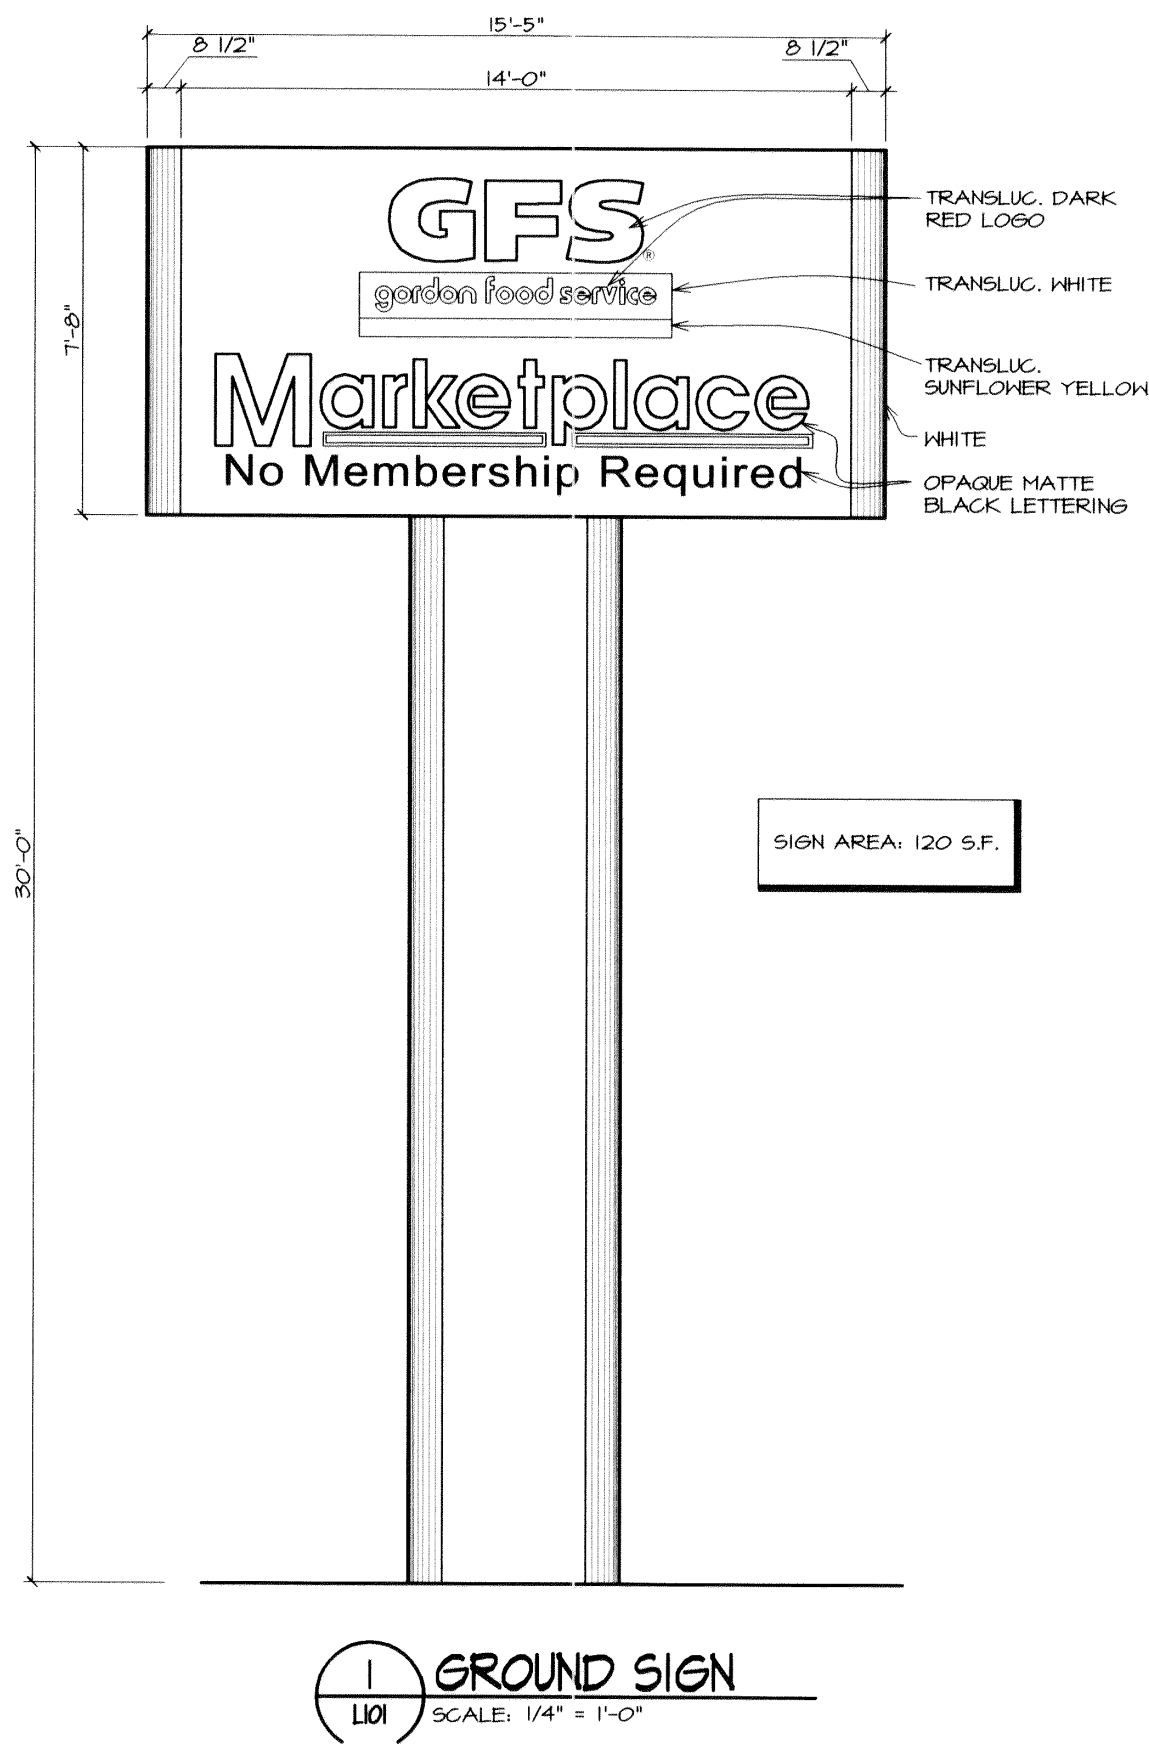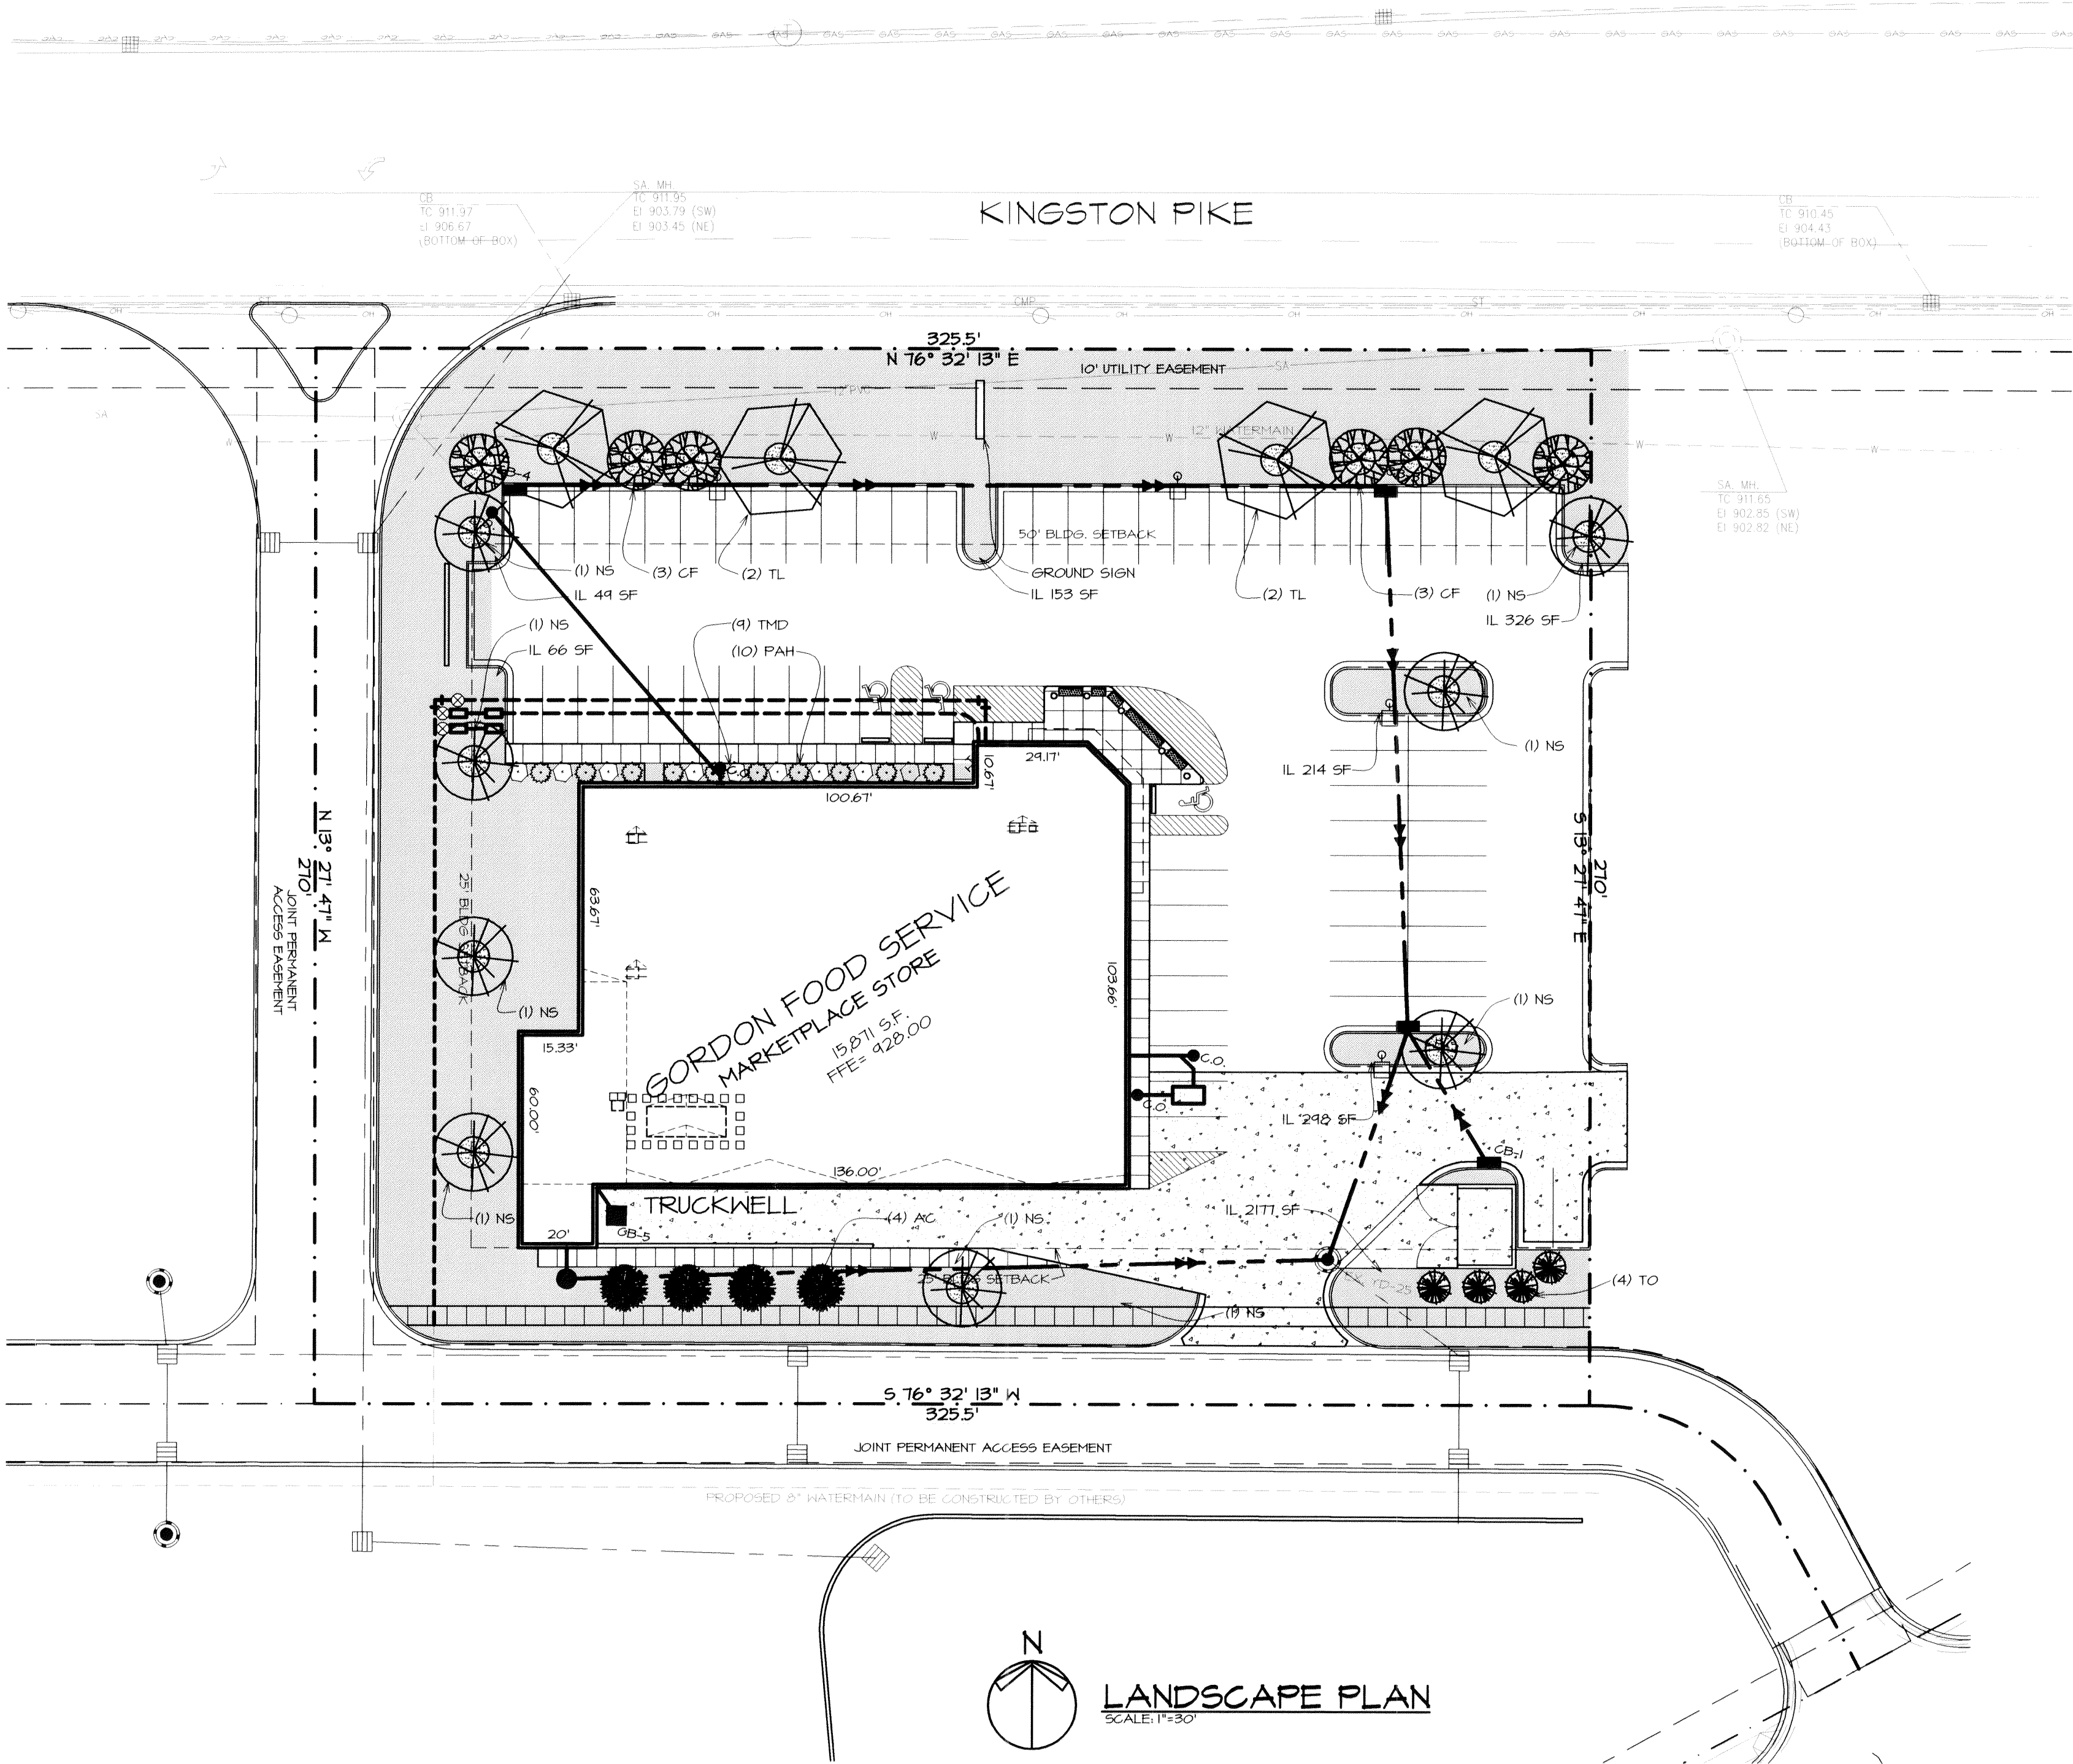

- NOTES:**
1. ALL LAWN AREAS TO HAVE 4"-6" OF SANDY LOAM TOPSOIL.
 2. SOD (SPEC.) PROVIDE STRONGLY ROOTED SOD, NOT LESS THAN TWO YEARS OLD, FREE OF WEEDS & UNDESIRABLE NATIVE GRASSES, AND MACHINE CUT TO PAD THICKNESS OF 3/4" (1/4" W/ EXCLUDING TOP GROWTH AND THATCH. PROVIDE ONLY SOD CAPABLE OF VIGOROUS GROWTH & DEVELOPMENT WHEN PLANTED (VIALE, NOT DORMANT).
 3. HYDROSEED (SPEC.) 100% - THIRD GENERATION PERENNIAL RYE GRASS WITH ENDOPHYTE. MULCH 90% VIRGIN WOOD FIBER WITH ORGANIC TACKIFIER APPLICATION RATE OF 1,250 POUNDS PER ACRE.
 4. FERTILIZER: 16-32-4 STARTER W/ SULFUR, IRON, MAGNESIUM QUICK RELEASE NITROGEN AND NO CHLORINE.
 5. ALL LAWN AREAS ARE TO BE FULLY IRRIGATED, UNLESS NOTED OTHERWISE. REFER TO DIVISION 02400 OF SPECS. AND SHEET E101 FOR 4" SCHEDULE 40 PVC SLEEVE LOCATIONS.
 6. TREES AND SHRUBS SHALL BE PLANTED WITH A PLANT MIX CONSISTING OF 1 PART TOPSOIL, 1 PART PEAT, AND 1 PART EXISTING SOIL.
 7. PLANT MATERIALS SHALL BE CHOSEN AND INSTALLED IN ACCORDANCE WITH STANDARDS RECOMMENDED BY THE COUNTY COOPERATIVE EXTENSION SERVICE OR AMERICAN NURSERY ASSOCIATION.
 8. ALL PLANTINGS SHALL BE MULCHED WITH 3" SHREDDED HARDWOOD MULCH ON KEEB BARRIER MATTING.
 9. PRUNE EXISTING TREES & SHRUBS TO SHAPE AND RELIEVATE. SELECTIVELY TRIMMED BY 25% MAINTAINING NATURAL SHAPE. ALL DEAD BRANCHES IN TREES SHALL ALSO BE PRUNED.
 10. PROTECT EXISTING TREES & SHRUBS TO REMAIN DURING CONSTRUCTION. PROVIDE FENCING AROUND ROOT ZONE DURING CONSTRUCTION IF REQUIRED.
 11. ELEVATE TREE BRANCHES MAINTAINING GOOD SHAPE AND CLEARANCE UNDERNEATH TREE.

NOTES:

ALL LANDSCAPE AND GRASS AREAS ARE TO BE FULLY IRRIGATED, UNLESS NOTED OTHERWISE.

SHADED AREAS
INDICATE SOIL.

HATCHED AREAS
INDICATE HYDROSEED.

HATCHED AREAS
INDICATE MULCH.

LANDSCAPE REQUIREMENTS

1 TREE PER 8 SPACES

71 SPACES / 8 = 8.875 = 9 TREES REQUIRED
14 TREES PROVIDED

STREET TREES - LARGE AND SMALL TREES PLANTED
ALONG KINGSTON PIKE AND OTHER DRIVEWAYS.

SYMBOL	KEY	QTY.	MATURITY	SIZE	COND.	COMMON NAME	BOTANICAL NAME
	NS	9	35' HT. 20' SPRD.	1-1/2" CAL.	B4B	TUPELO	NYSSA SYLVATICA
	AC	4	15' HT. 10' SPRD.	1-1/2" CAL.	B4B	WHITE FIR	ABIES CONCOLOR
	TO	4	30' HT. 12' SPRD.	1-1/2" CAL.	B4B	AMERICAN ARBORVITAE	THUJA OCCIDENTALIS
	TMD	4	3'-4' HT. 4'-6" SPRD.	18"	B4B	DENSE YEW	TAXUS X MEDIA DENSIFORMIS
	PAH	10	2' HT. 15'-2" SPRD.	1 GAL.	B4B	DWARF FOUNTAIN GRASS	PENNISETUM ALOPEGURIODES 'MABEL'
	TL	4	60' HT. 30' SPRD.	1 1/2" CAL.	B4B	AMERICAN LINDEN BOULEVARD	TILIA AMERICANA 'BOULEVARD'
	CF	6	20-25' HT. 20' SPRD.	1-1/2" CAL.	B4B	WHITE FLOERING DOGWOOD	CORNUS FLORIDA

ARCHITECTS • CIVIL ENGINEERS

paradigm design

550 3 MILE N.W.
SUITE B
GRAND RAPIDS, MI 49544

PHONE (616) 785 • 5656
FAX (616) 785 • 5657
WEB PARADIGMAE.COM

PROJECT

GORDON FOOD SERVICE MARKETPLACE STORE

(PART OF) SHERRILL HILLS DEVELOPMENT

9320 KINGSTON PIKE (APPROX.) KNOXVILLE, TN

GFS MARKETPLACE, LLC

420 50TH STREET SW
GRAND RAPIDS, MICHIGAN

RELEASE DATE

12-22-09 USE ON REVIEW
1-26-10 REVISED PER CITY STAFF REVIEW

2-D-10-00
REVISED
1-28-10

PROJECT

0902021





SHEET

L 101

LANDSCAPE PLAN



RELEASE DATE	
12-22-09	USE ON REVIEW
1-26-10	REVISED PER CITY STAFF REVIEW
	2-D-10-UR REVISED 1-28-10
PROJECT	
	0902021
SHEET	
A	101

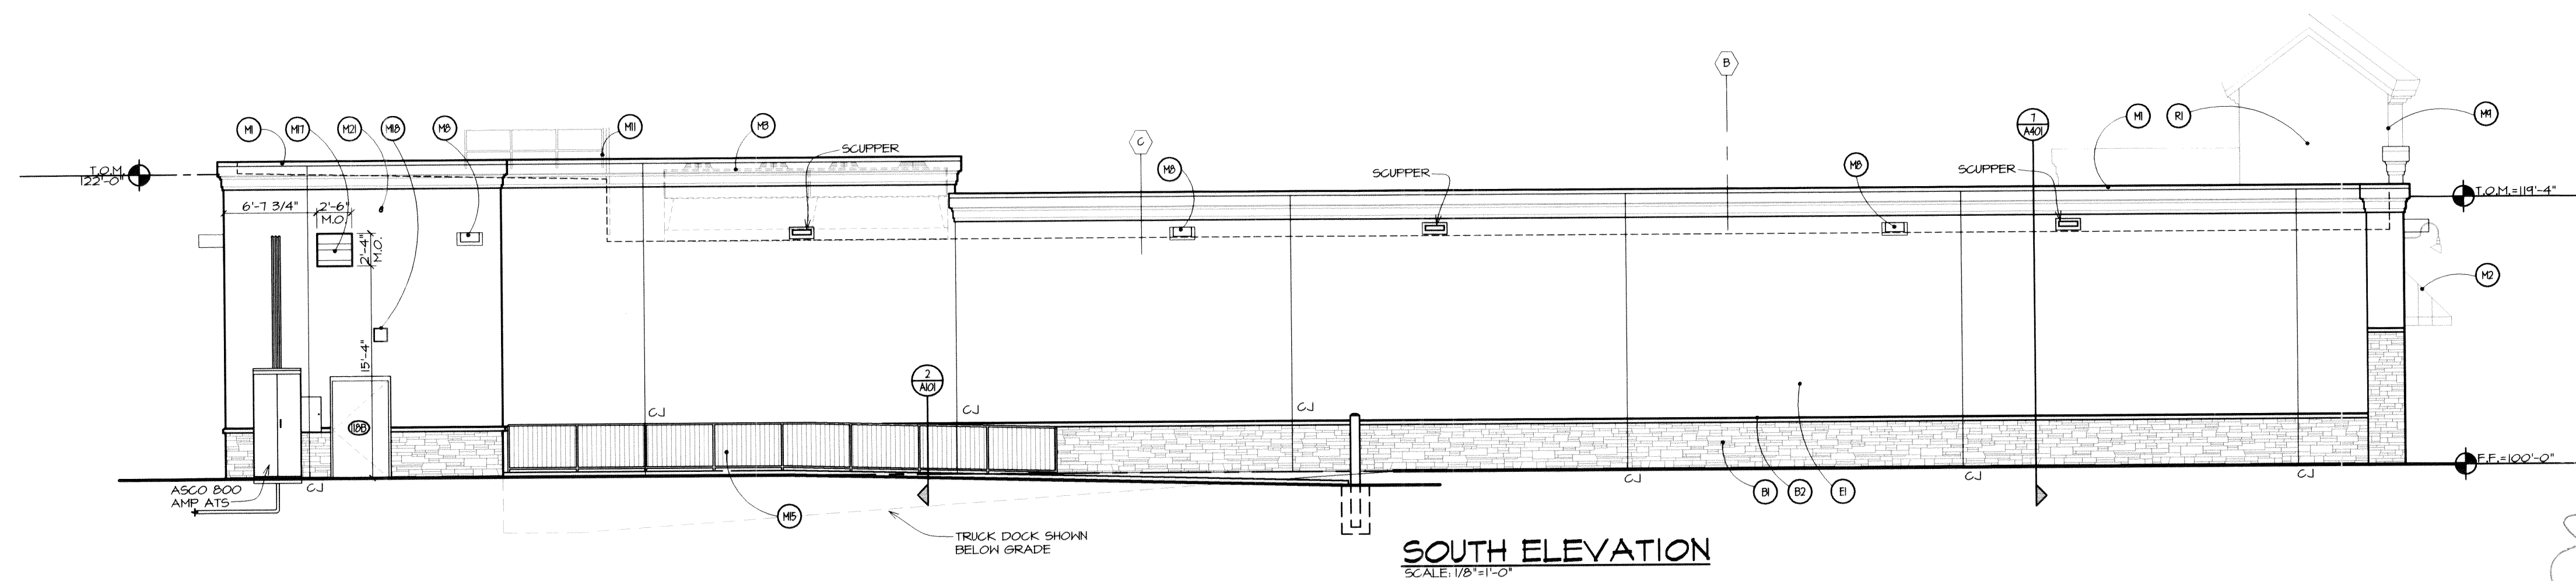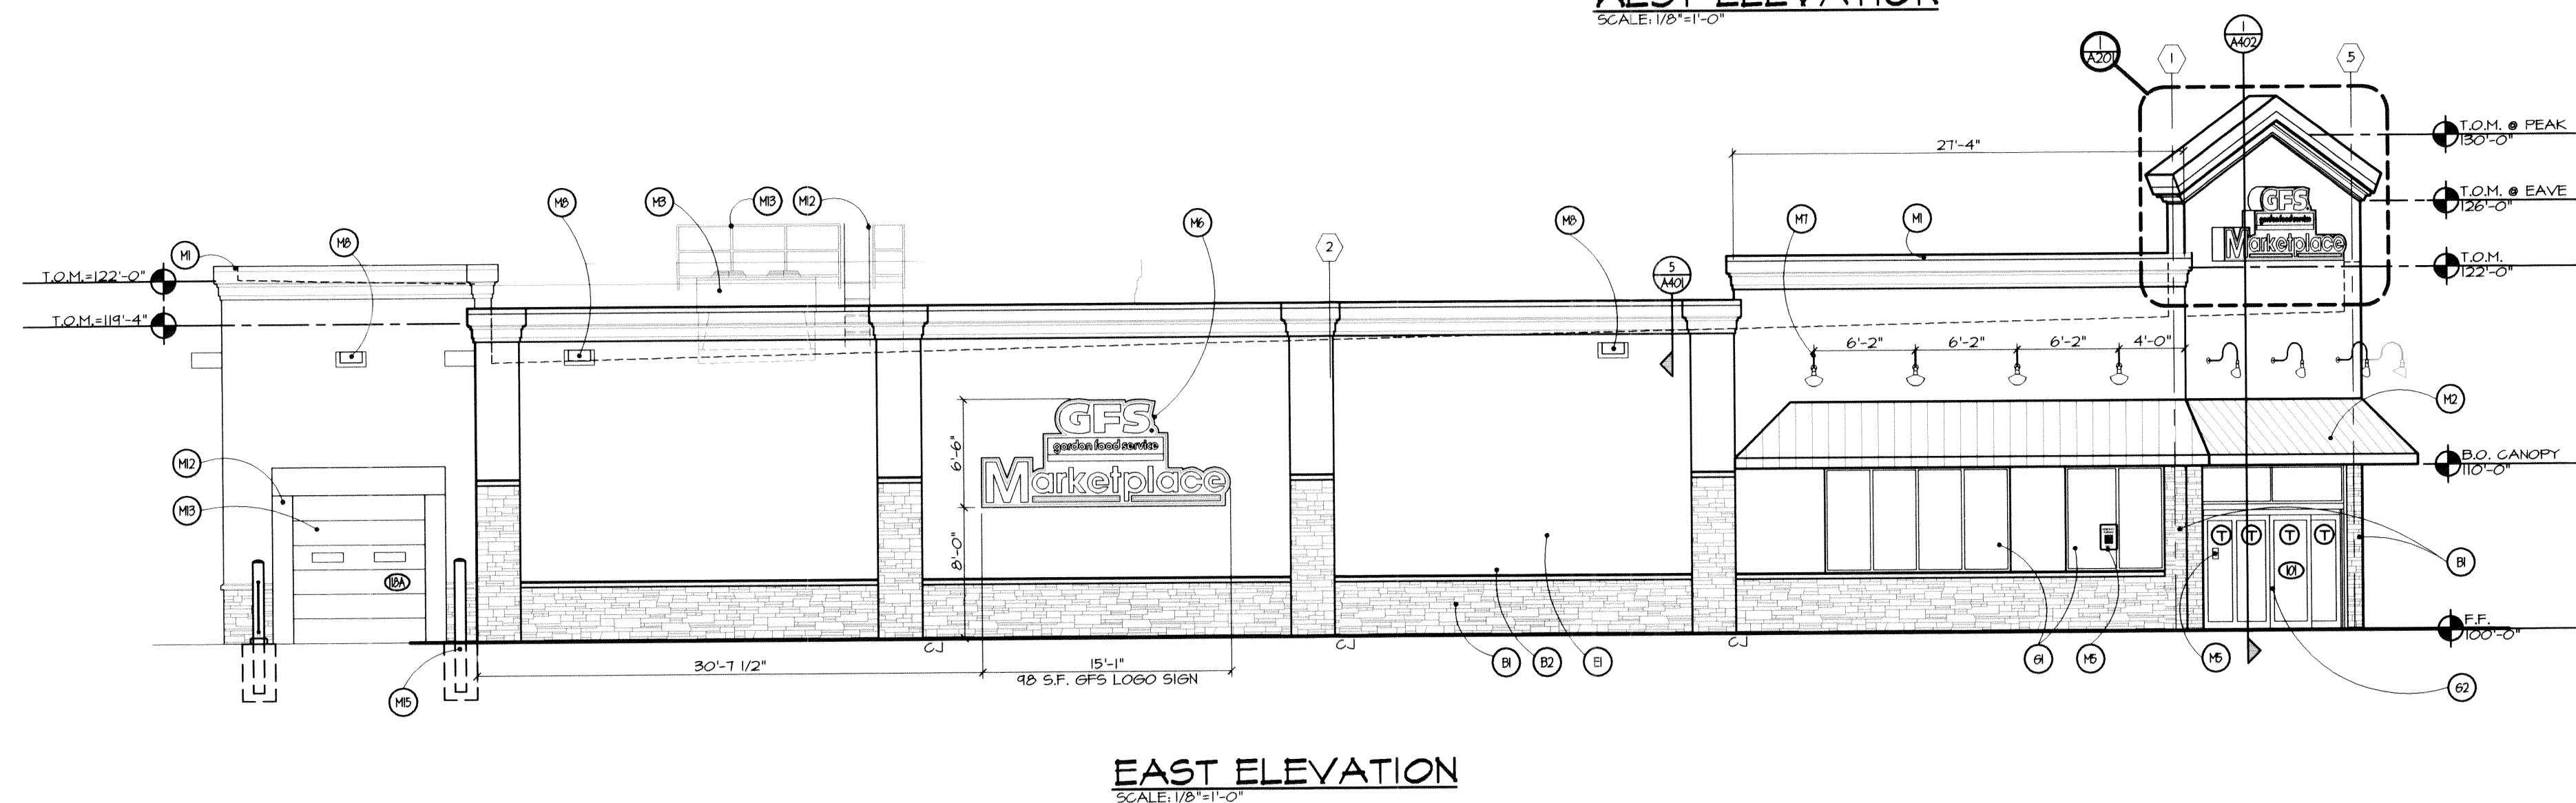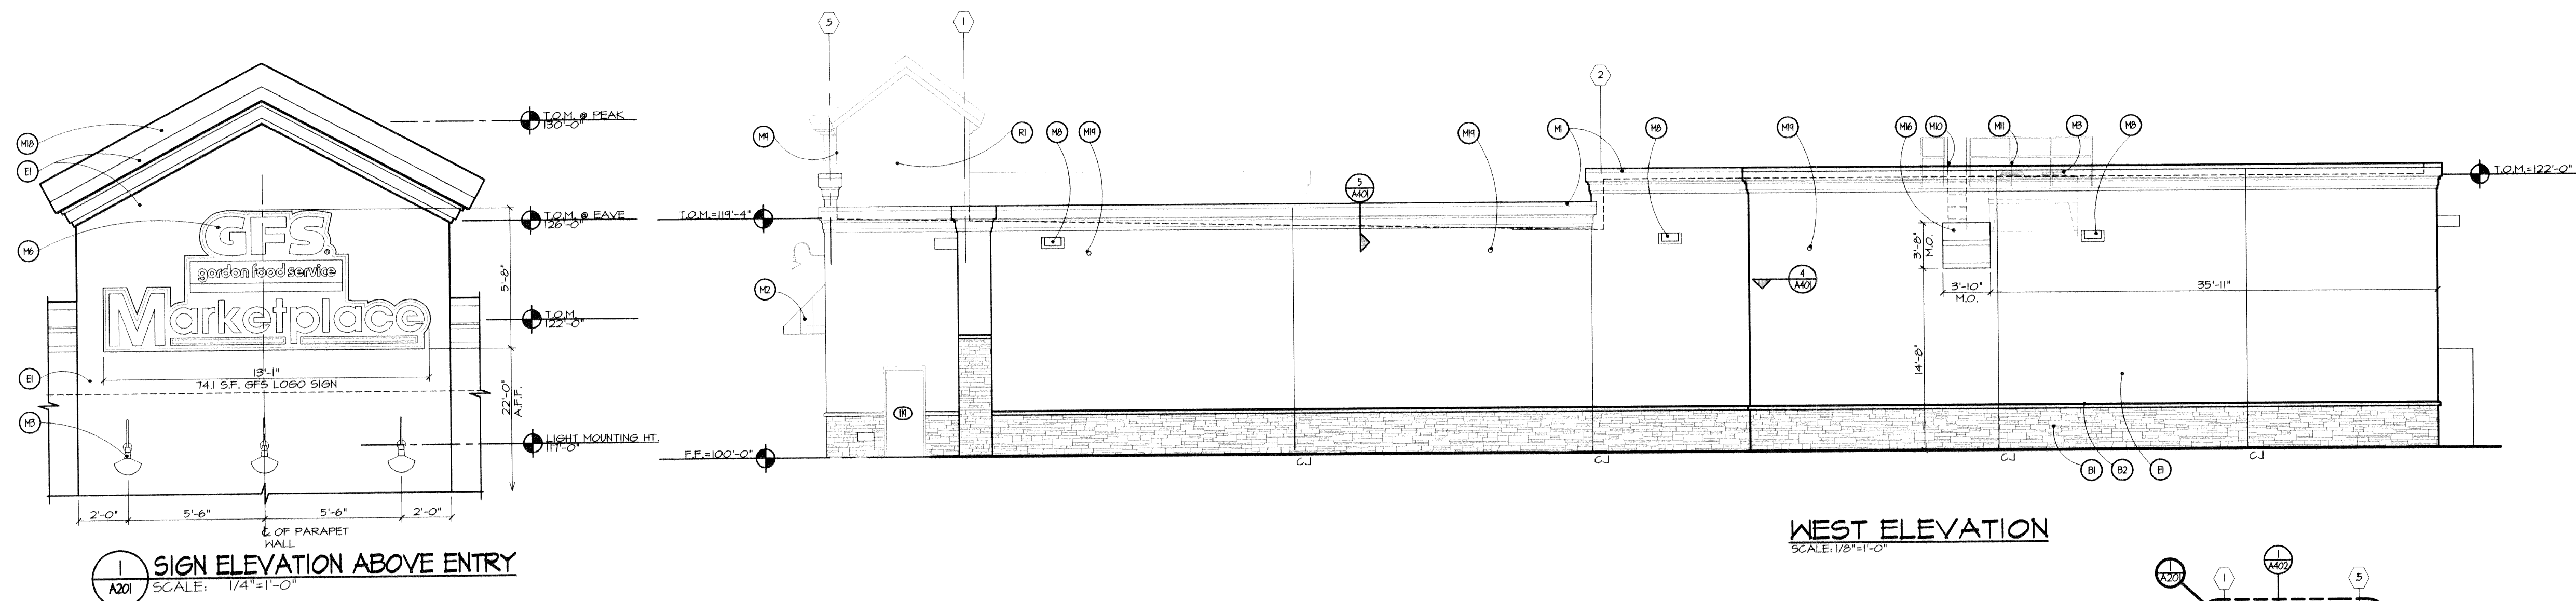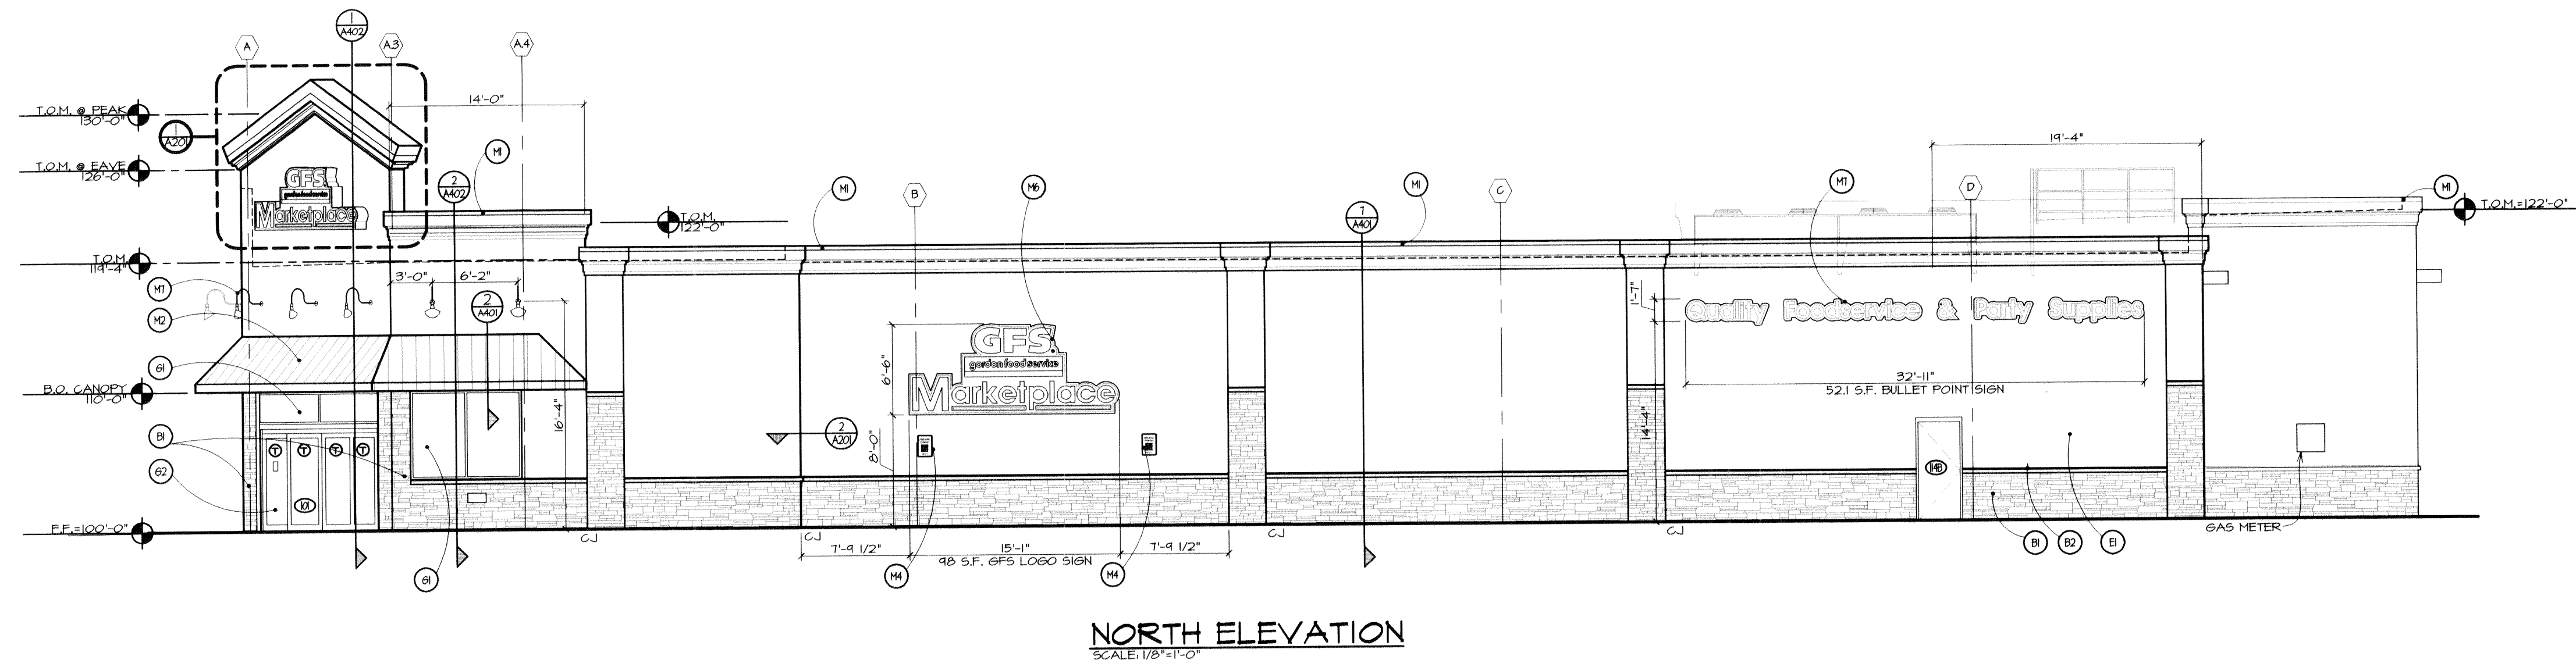

MATERIAL LEGEND

- | | |
|-----|--|
| B1 | SYNTHETIC STONE BY CENTURIUM - COLOR TO MATCH "KENTUCKY RUSTIC" OR EQUAL. |
| B2 | PRECAST CONCRETE TRIM, 1,000 PSI MIN. - COLOR TO BE "NATURAL GRAY" - REFER TO DETAIL 11/A402. |
| B3 | DUMPMSTER ENCLOSURE - SEE SHEET A202 |
| E1 | EXTERIOR INSULATION FINISH SYSTEM (E.I.F.S.) COLOR TO BE STG #0308 "PEARL." |
| G1 | 1" INSULATED GLASS (TEMPERED WHERE NOTED) IN "CLEAR ANODIZED" ALUMINUM FRAME - SEE A401 FOR WINDOW SIZES |
| G2 | AUTOMATIC ALUMINUM ENTRY SYSTEM IN "CLEAR ANODIZED" FRAMING W/ 5/8" GLASS IN DOOR AND 5/8" INSULATED GLASS IN SIDELITES |
| M1 | PREFINISHED METAL CAP FLASHING - COLOR TO MATCH BERRIDGE "DEEP RED" |
| M2 | PREFINISHED STANDING SEAM METAL ROOF PANELS - COLOR TO MATCH BERRIDGE "DEEP RED" - PROVIDE CLEAR SNOO CLEATS BETWEEN EACH RIP - STAGGERED. |
| M3 | CONDENSOR UNIT BY REFRIGERATOR CONTRACTOR |
| M4 | H.C. PARKING SIGN MOUNTED ON BUILDING - REFER TO 11/C401 |
| M5 | H.C. PARKING SIGN MOUNTED ON GLASS |
| M6 | SURFACE MOUNTED SIGN BY OWNER. COORDINATE WITH SIGN CO. TO PROVIDE TEMPLATE & J.B. LOCATIONS. |
| M1 | 600# NECK LIGHT FIXTURE - COLOR TO BE "BLACK" - REFER TO ELECTRICAL PLANS. |
| M6 | LIGHT SEE ELECTRICAL PLANS. (1) BLOCK & SMOOTHECAST CONCRETE BLOCK - COLOR TO BE "WHITE SANDS" W/ MIDPOINT SCORE FOR MOUNTING OF LIGHT FIXTURE. (2) VERIFY LOCATIONS W/ ELECTRICAL CONTRACTOR. |
| M1 | VERTICAL TERMINATION BAR FOR T.P.O. MEMBRANE THERMOPLASTIC POLYOLEFIN FLASHING |
| M10 | STEEL HIGH/LOW ROOF LADDER - SEE DETAIL 11/S501, WHITE |
| M11 | STEEL GUARD RAIL AT ROOF HATCH - SEE DETAIL 11/A401, WHITE |
| M12 | DOCK SEAL |
| M13 | OVERHEAD DOOR |
| M14 | 6" BUMP POST - COLOR TO MATCH BERRIDGE "DEEP RED" |
| M15 | 6" BUMP POST - COLOR TO MATCH BERRIDGE "DEEP RED" |
| M16 | INTAKE RAIN HOOD BY MECHANICAL CONTRACTOR - SEE DETAIL 11/A401 |
| M17 | EXHAUST LOUVER/RAIN HOOD BY MECHANICAL CONTRACTOR - SEE DETAIL 11/A401 |
| M18 | EX. FAN WALL CAP - VERIFY W/ MECHANICAL PLANS |
| M19 | CONCENTRIC VENT TERMINAL KIT, REFER TO MECHANICAL DRAWINGS. |
| M20 | 24"x24" LOUVER - PAINT, REFER TO A401 |
| M21 | 3" Ø HOT WATER VENT |
| R1 | ROOF MEMBRANE - REFER TO SPECIFICATION |

NOTES:

REFER TO SHEET S401 FOR REQUIRED SEISMIC
REINF. AT MASONRY OPENINGS

ALL EXTERIOR MASONRY WALLS AND MORTAR
CONTAIN INTEGRAL WATER REPELLENT SYSTEM -
RHEOPEL OR EQUAL.

ARCHITECTS • CIVIL ENGINEERS

paradigm
design

550 3 MILE N.W.

SUITE 8

GRAND RAPIDS, MI 49544

PHONE (616) 785 - 5656

FAX (616) 785 • 5657

WEB PARADIGMAE.COM

PROJECT

**GORDON
FOOD
SERVICE
MARKETPLACE
STORE**

(PART OF SHERRILL HILLS
DEVELOPMENT)

9320 KINGSTON PIKE (APPROX.)
KNOXVILLE, TN

**GFS
MARKETPLACE, LLC**

420 51TH STREET SW
GRAND RAPIDS, MICHIGAN

RELEASE DATE

12-22-09 USE ON REVIEW

1-26-10 REVISED PER CITY STAFF REVIEW

2-D-10-UR
REVISED
1-28-10

PROJECT

0902021

SHEET

A 201

John Thur
1-26-10

